


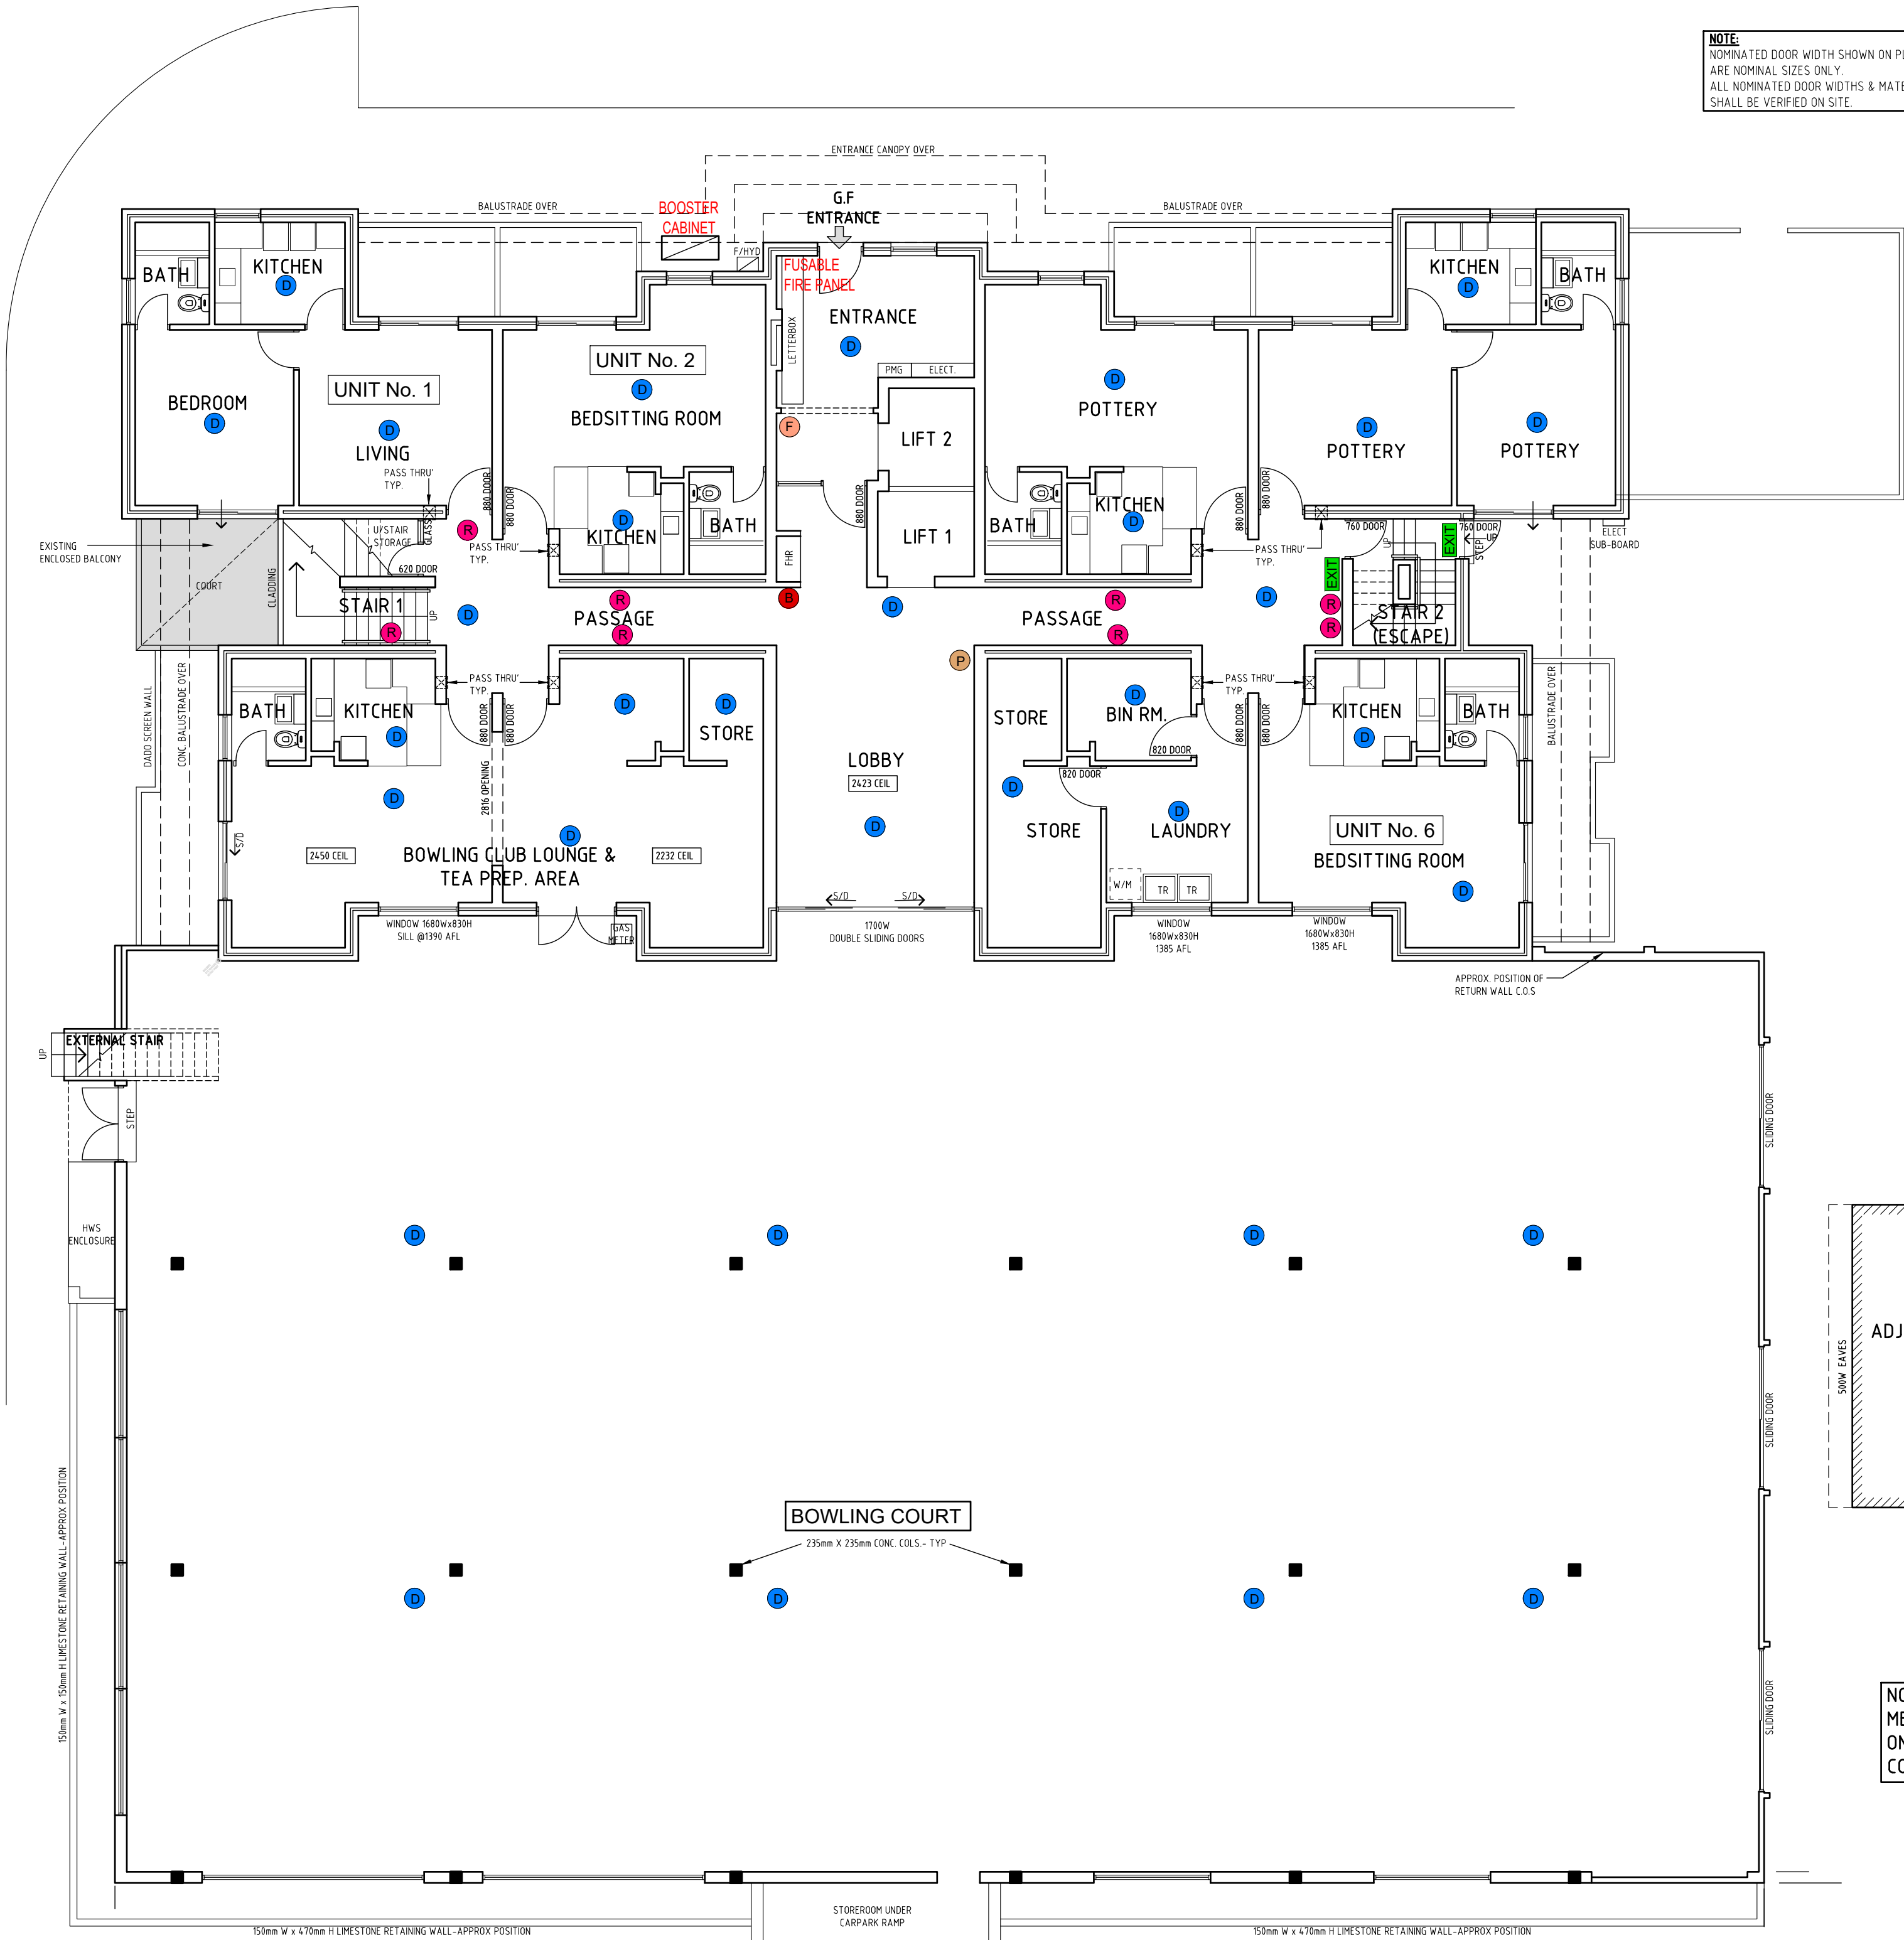



NOTE:
NOMINATED DOOR WIDTH SHOWN ON PLAN
ARE NOMINAL SIZES ONLY.
ALL NOMINATED DOOR WIDTHS & MATERIALS
SHALL BE VERIFIED ON SITE.

EXISTING SERVICES LEGEND

- B** ALARM BELL.
- D** DETECTOR
- EXIT** EXIT SIGN
- F** FIRE EXTINGUISHER (3.5kg / CO2)
- P** EXIT PLAN
- R** FIRE ALARM IN ROOM INDICATOR

NOTE:
THESE FIRE SERVICES AS CONSTRUCTED
ARCHITECTURAL DRAWINGS ARE SUBJECT
TO FIRE CONSULTANT/S REVIEW DOCUMENTATION

Ground Floor Plan / Bowling Court

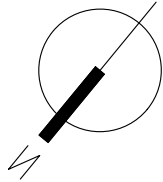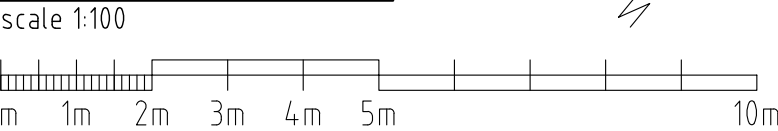

ADJACENT BUILDING OUTLINE

500W EAVES

800W EAVES

NOTE:
MEASURE & CHECK ALL DIMENSIONS
ON SITE TO CONFIRM LAYOUT PRIOR TO
CONSTRUCTION

PRELIMINARY DRAWING
NOT FOR CONSTRUCTION

AS CONSTRUCTED
AS AT 22.02.2024

NOTE:
THESE ARE CAD CONVERSION DRAWINGS
FROM IMPERIAL AND ARE
NOT TO BE USED FOR
CONSTRUCTION PURPOSES

REV	DESCRIPTION	DATE

VISTA DESIGNS
Building Designers

SUITE 3, 279 LORD STREET
EAST PERTH 6004
TEL./FAX: 922771415
© COPYRIGHT

SWAN CARE RICHARD CLEAVER LODGE
34 Graham Cres,
BENTLEY WA 6102

Drawing Title
Existing Ground Floor / Bowling Court Plan
Fire Services

Drawn	Scale 1:100, BAZ	Date 09.10.25	Job No. 3097	Drawing No.	Rev
				FS1 of 8	-

Check all dimensions on site prior to commencement of any works
Unauthorized copying or distribution of this drawing is strictly
prohibited. Copyright © 2023

NOTE:
NOMINATED DOOR WIDTH SHOWN ON PLAN
ARE NOMINAL SIZES ONLY.
ALL NOMINATED DOOR WIDTHS & MATERIALS
SHALL BE VERIFIED ON SITE.



EXISTING SERVICES LEGEND

- B ALARM BELL.
- D DETECTOR
- EXIT EXIT SIGN
- F FIRE EXTINGUISHER (3.5kg / CO2)
- P EXIT PLAN
- R FIRE ALARM IN ROOM INDICATOR

NOTE:
THESE FIRE SERVICES AS CONSTRUCTED
ARCHITECTURAL DRAWINGS ARE SUBJECT
TO FIRE CONSULTANT/S REVIEW DOCUMENTATION

Floor Plan Level 1

 scale 1:100

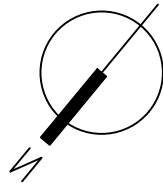

PRELIMINARY DRAWING
NOT FOR CONSTRUCTION

AS CONSTRUCTED
AS AT 22.02.2024

NOTE:
THESE ARE CAD CONVERSION DRAWINGS
FROM IMPERIAL AND ARE
NOT TO BE USED FOR
CONSTRUCTION PURPOSES

REV	DESCRIPTION	DATE
-	-	-

VISTA DESIGNS
Building Designers

SUITE 3, 279 LORD STREET
EAST PERTH 6004
TEL./FAX: 9227714/5
© COPYRIGHT

SWAN CARE RICHARD CLEAVER LODGE
34 Graham Cres,
BENTLEY WA 6102

Drawing Title Existing Level 1 Fire Services	Scale 1/50, 1/25	Date 01.10.25	Job No. 3097	Drawing No. FS2 of 8	Rev -
--	---------------------	------------------	-----------------	-------------------------	----------

Check all dimensions on site prior to commencement of any works
Unauthorized copying or distribution of this drawing is strictly
prohibited. Copyright © 2023


NOTE:
MEASURE & CHECK ALL DIMENSIONS
ON SITE TO CONFIRM LAYOUT PRIOR TO
CONSTRUCTION



NOTE:
NOMINATED DOOR WIDTH SHOWN ON PLAN
ARE NOMINAL SIZES ONLY.
ALL NOMINATED DOOR WIDTHS & MATERIALS
SHALL BE VERIFIED ON SITE.



EXISTING SERVICES LEGEND

- B ALARM BELL.
- D DETECTOR
- EXIT EXIT SIGN
- F FIRE EXTINGUISHER (3.5kg / CO2)
- P EXIT PLAN
- R FIRE ALARM IN ROOM INDICATOR

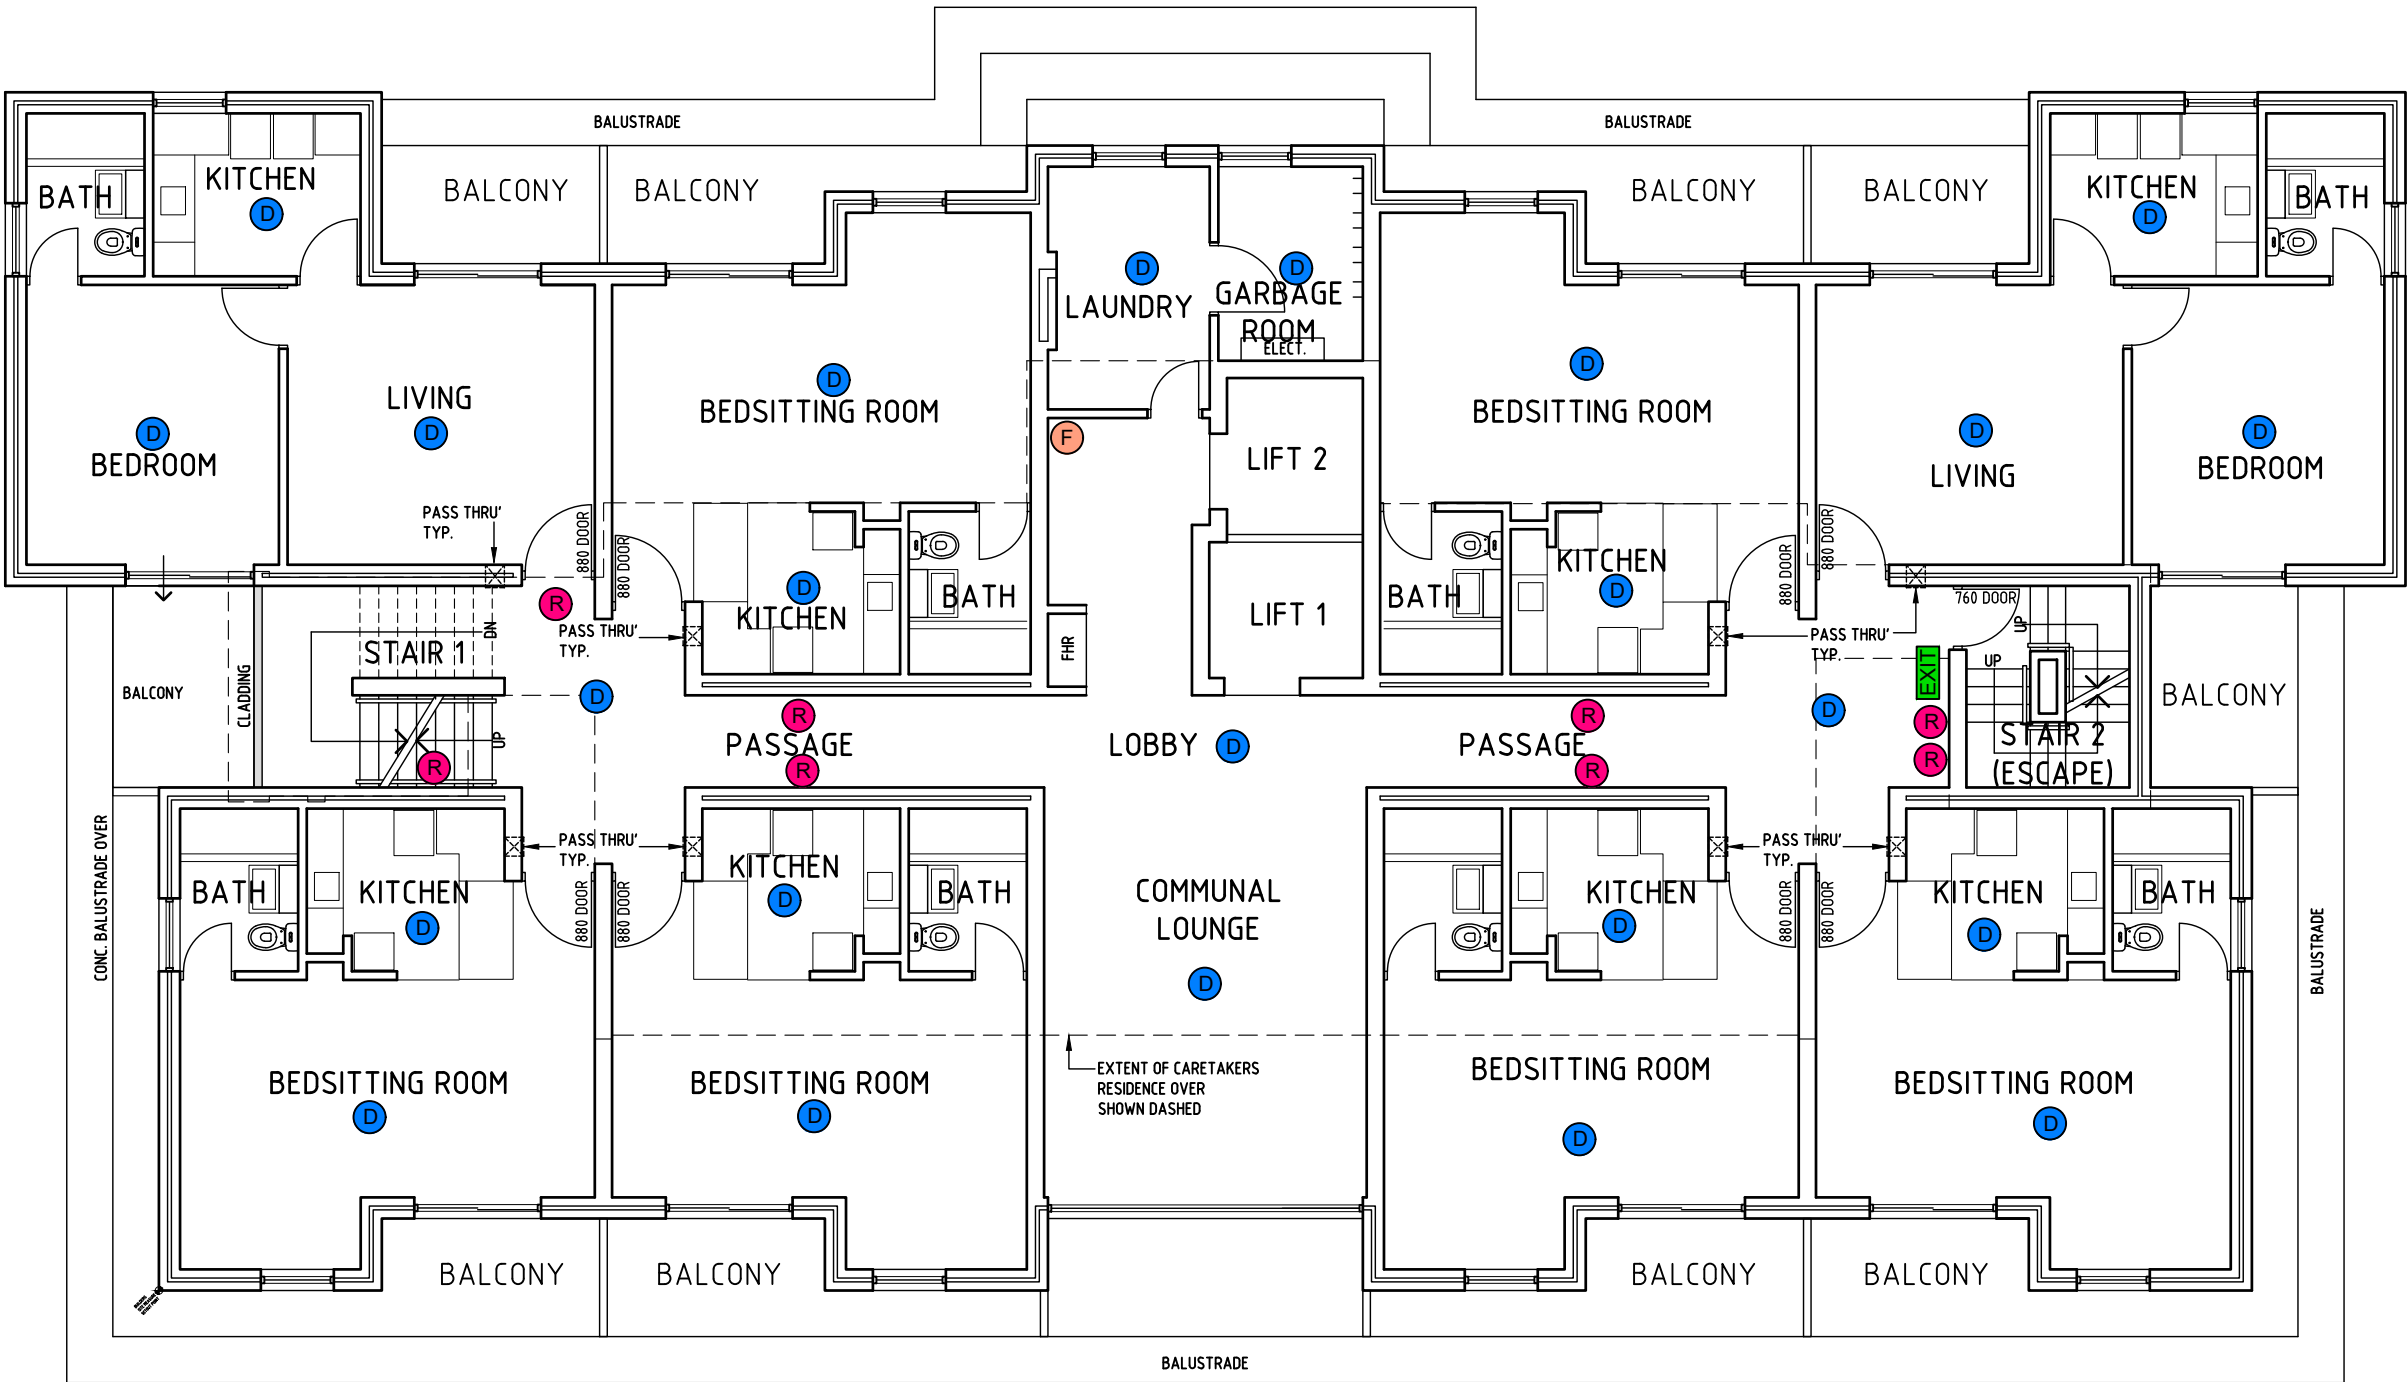

Floor Plan Level 2

 scale 1:100

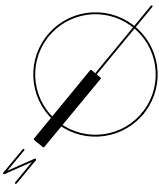

NOTE:
THESE FIRE SERVICES AS CONSTRUCTED
ARCHITECTURAL DRAWINGS ARE SUBJECT
TO FIRE CONSULTANT/S REVIEW DOCUMENTATION

PRELIMINARY DRAWING
NOT FOR CONSTRUCTION

AS CONSTRUCTED
AS AT 22.02.2024

NOTE:
THESE ARE CAD CONVERSION DRAWINGS
FROM IMPERIAL AND ARE
NOT TO BE USED FOR
CONSTRUCTION PURPOSES

REV	DESCRIPTION	DATE
-	-	-

VISTA DESIGNS
Building Designers

SUITE 3, 279 LORD STREET
EAST PERTH 6004
TEL./FAX: 922771415
© COPYRIGHT

SWAN CARE RICHARD CLEAVER LODGE
34 Graham Cres,
BENTLEY WA 6102

Drawing Title
Existing Level 2
Fire Services

Drawn	Scale	Date	Job No.	Drawing No.	Rev
1/100, BAZ	01.10.25	3097		FS3 of 8	-


Check all dimensions on site prior to commencement of any works
Unauthorized copying or distribution of this drawing is strictly
prohibited. Copyright © 2023

NOTE:
MEASURE & CHECK ALL DIMENSIONS
ON SITE TO CONFIRM LAYOUT PRIOR TO
CONSTRUCTION

NOTE:
NOMINATED DOOR WIDTH SHOWN ON PLAN
ARE NOMINAL SIZES ONLY.
ALL NOMINATED DOOR WIDTHS & MATERIALS
SHALL BE VERIFIED ON SITE.



EXISTING SERVICES LEGEND

- B ALARM BELL.
- D DETECTOR
- EXIT EXIT SIGN
- F FIRE EXTINGUISHER (3.5kg / CO2)
- P EXIT PLAN
- R FIRE ALARM IN ROOM INDICATOR

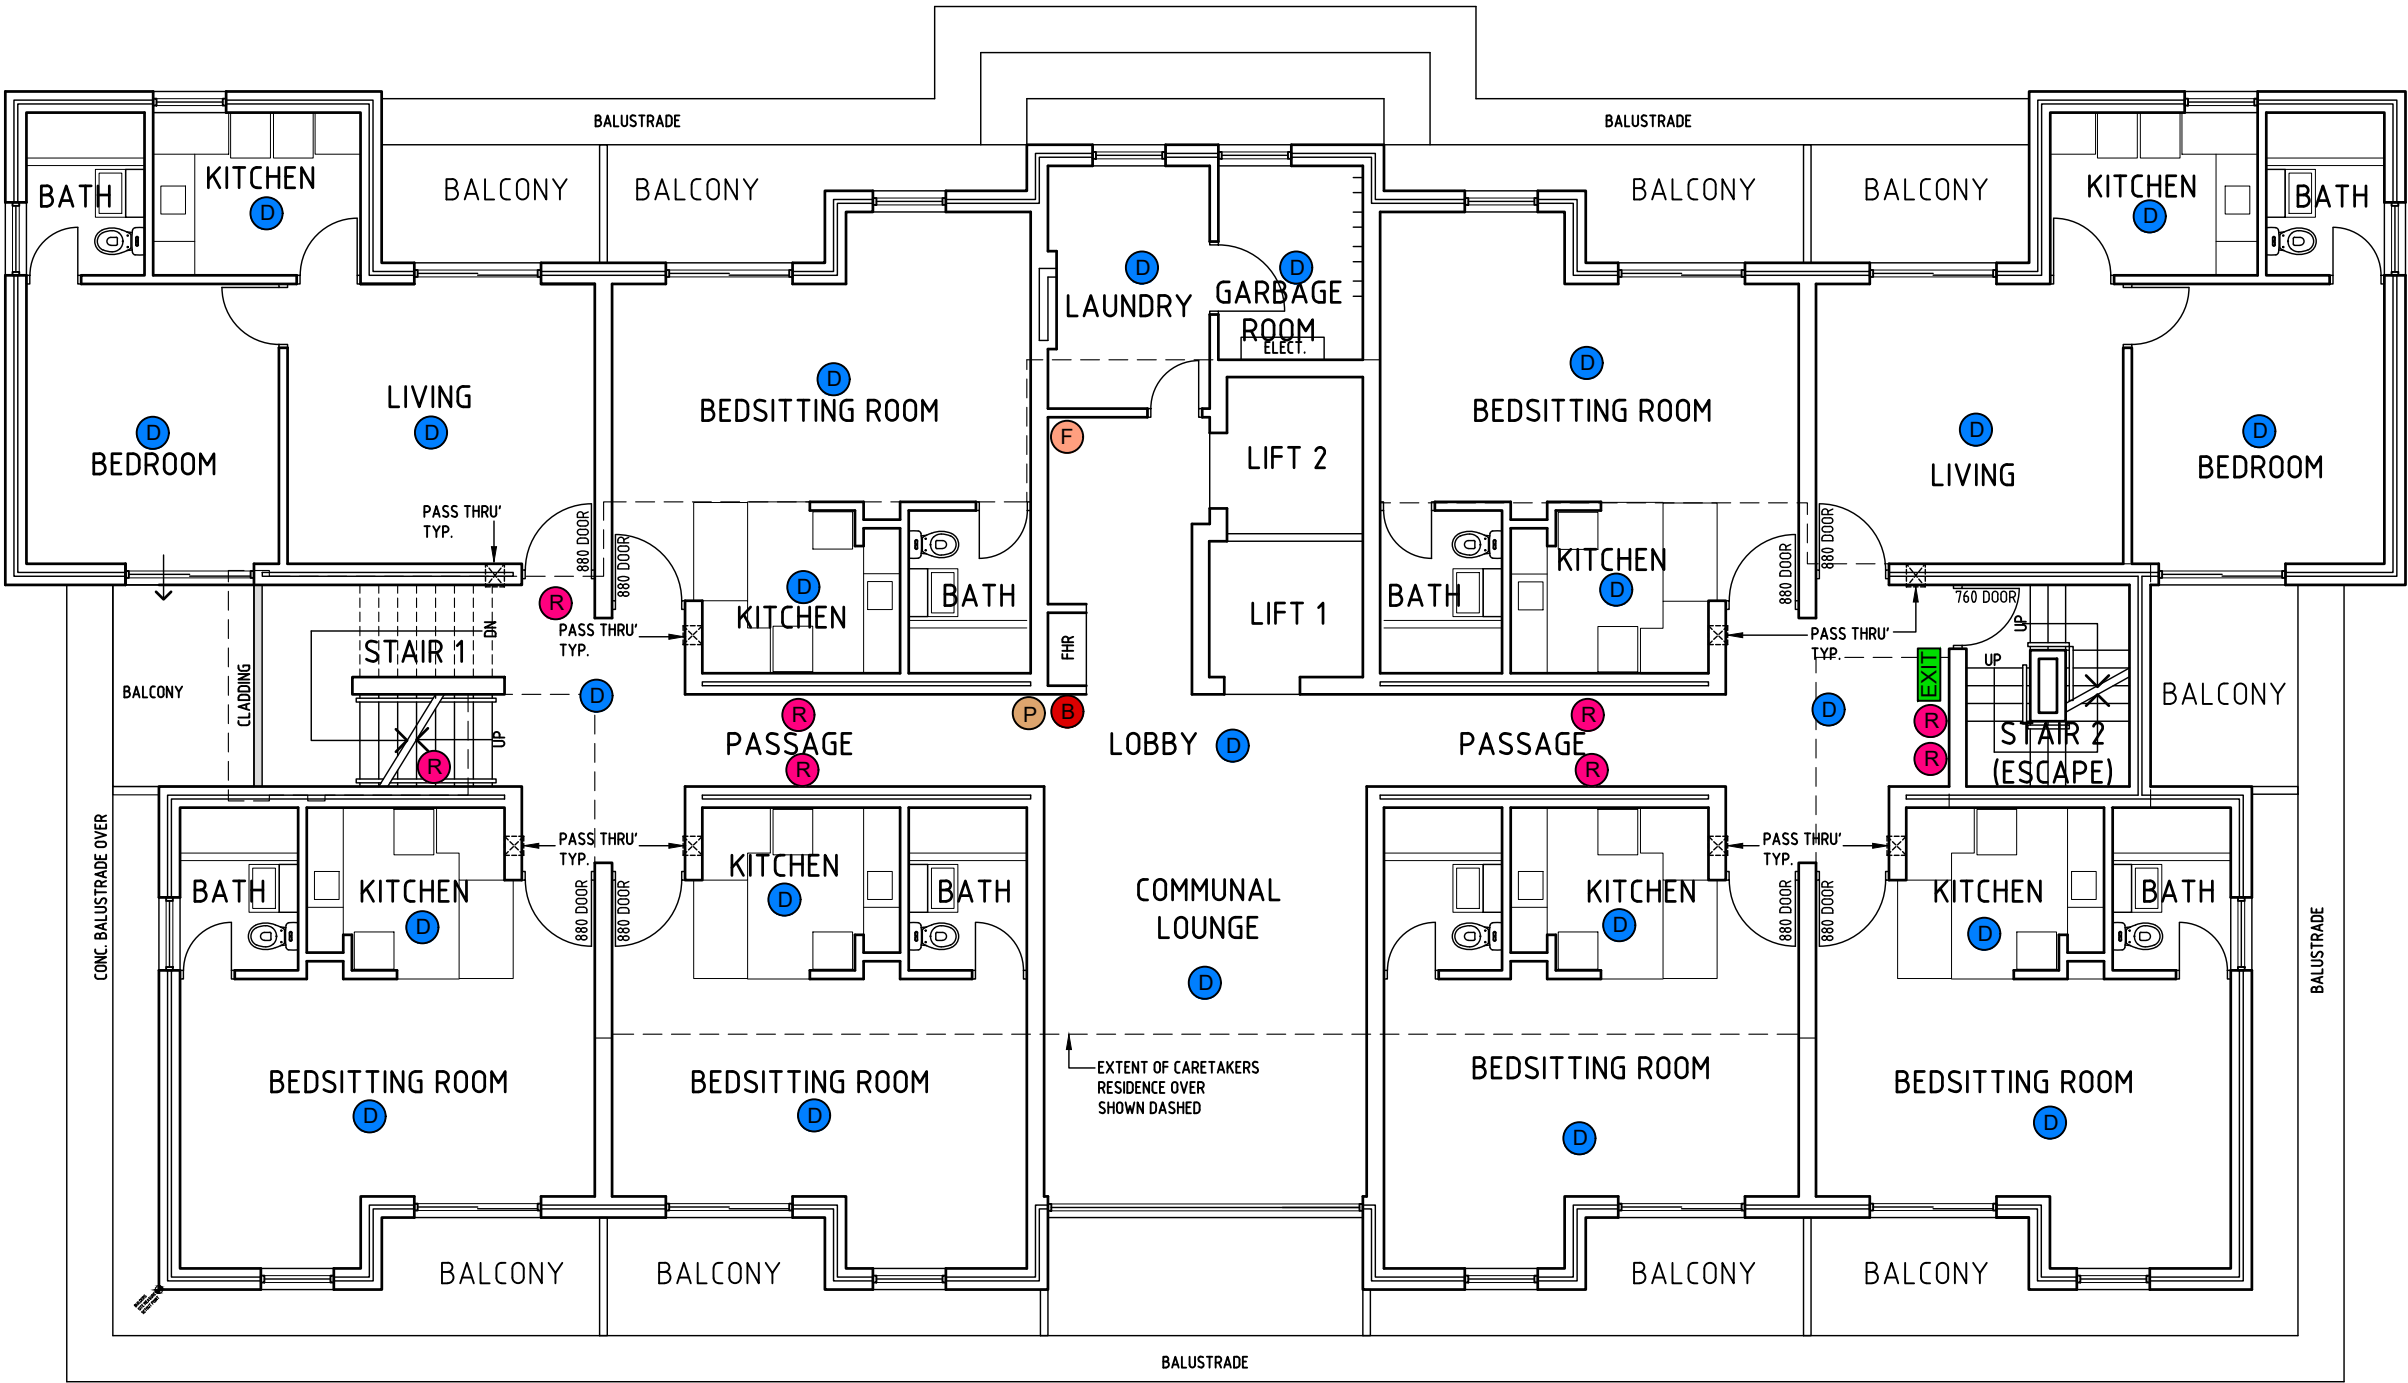

Floor Plan Level 3

 scale 1:100

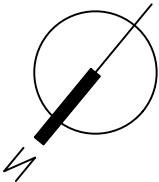

NOTE:
THESE FIRE SERVICES AS CONSTRUCTED
ARCHITECTURAL DRAWINGS ARE SUBJECT
TO FIRE CONSULTANT/S REVIEW DOCUMENTATION

PRELIMINARY DRAWING
NOT FOR CONSTRUCTION

AS CONSTRUCTED
AS AT 22.02.2024

NOTE:
THESE ARE CAD CONVERSION DRAWINGS
FROM IMPERIAL AND ARE
NOT TO BE USED FOR
CONSTRUCTION PURPOSES

REV	DESCRIPTION	DATE
-	-	-

VISTA DESIGNS
Building Designers

SUITE 3, 279 LORD STREET
EAST PERTH 6004
TEL./FAX: 922771415
© COPYRIGHT

SWAN CARE RICHARD CLEAVER LODGE
34 Graham Cres,
BENTLEY WA 6102


Drawing Title Existing Level 3 Fire Services	Scale 1/500, BAZ	Date 01.10.25	Job No. 3097	Drawing No. FS4 of 8	Rev -
--	---------------------	------------------	-----------------	-------------------------	----------

NOTE:
MEASURE & CHECK ALL DIMENSIONS
ON SITE TO CONFIRM LAYOUT PRIOR TO
CONSTRUCTION

NOTE:
NOMINATED DOOR WIDTH SHOWN ON PLAN
ARE NOMINAL SIZES ONLY.
ALL NOMINATED DOOR WIDTHS & MATERIALS
SHALL BE VERIFIED ON SITE.



EXISTING SERVICES LEGEND

- B ALARM BELL.
- D DETECTOR
- EXIT EXIT SIGN
- F FIRE EXTINGUISHER (3.5kg / CO2)
- P EXIT PLAN
- R FIRE ALARM IN ROOM INDICATOR

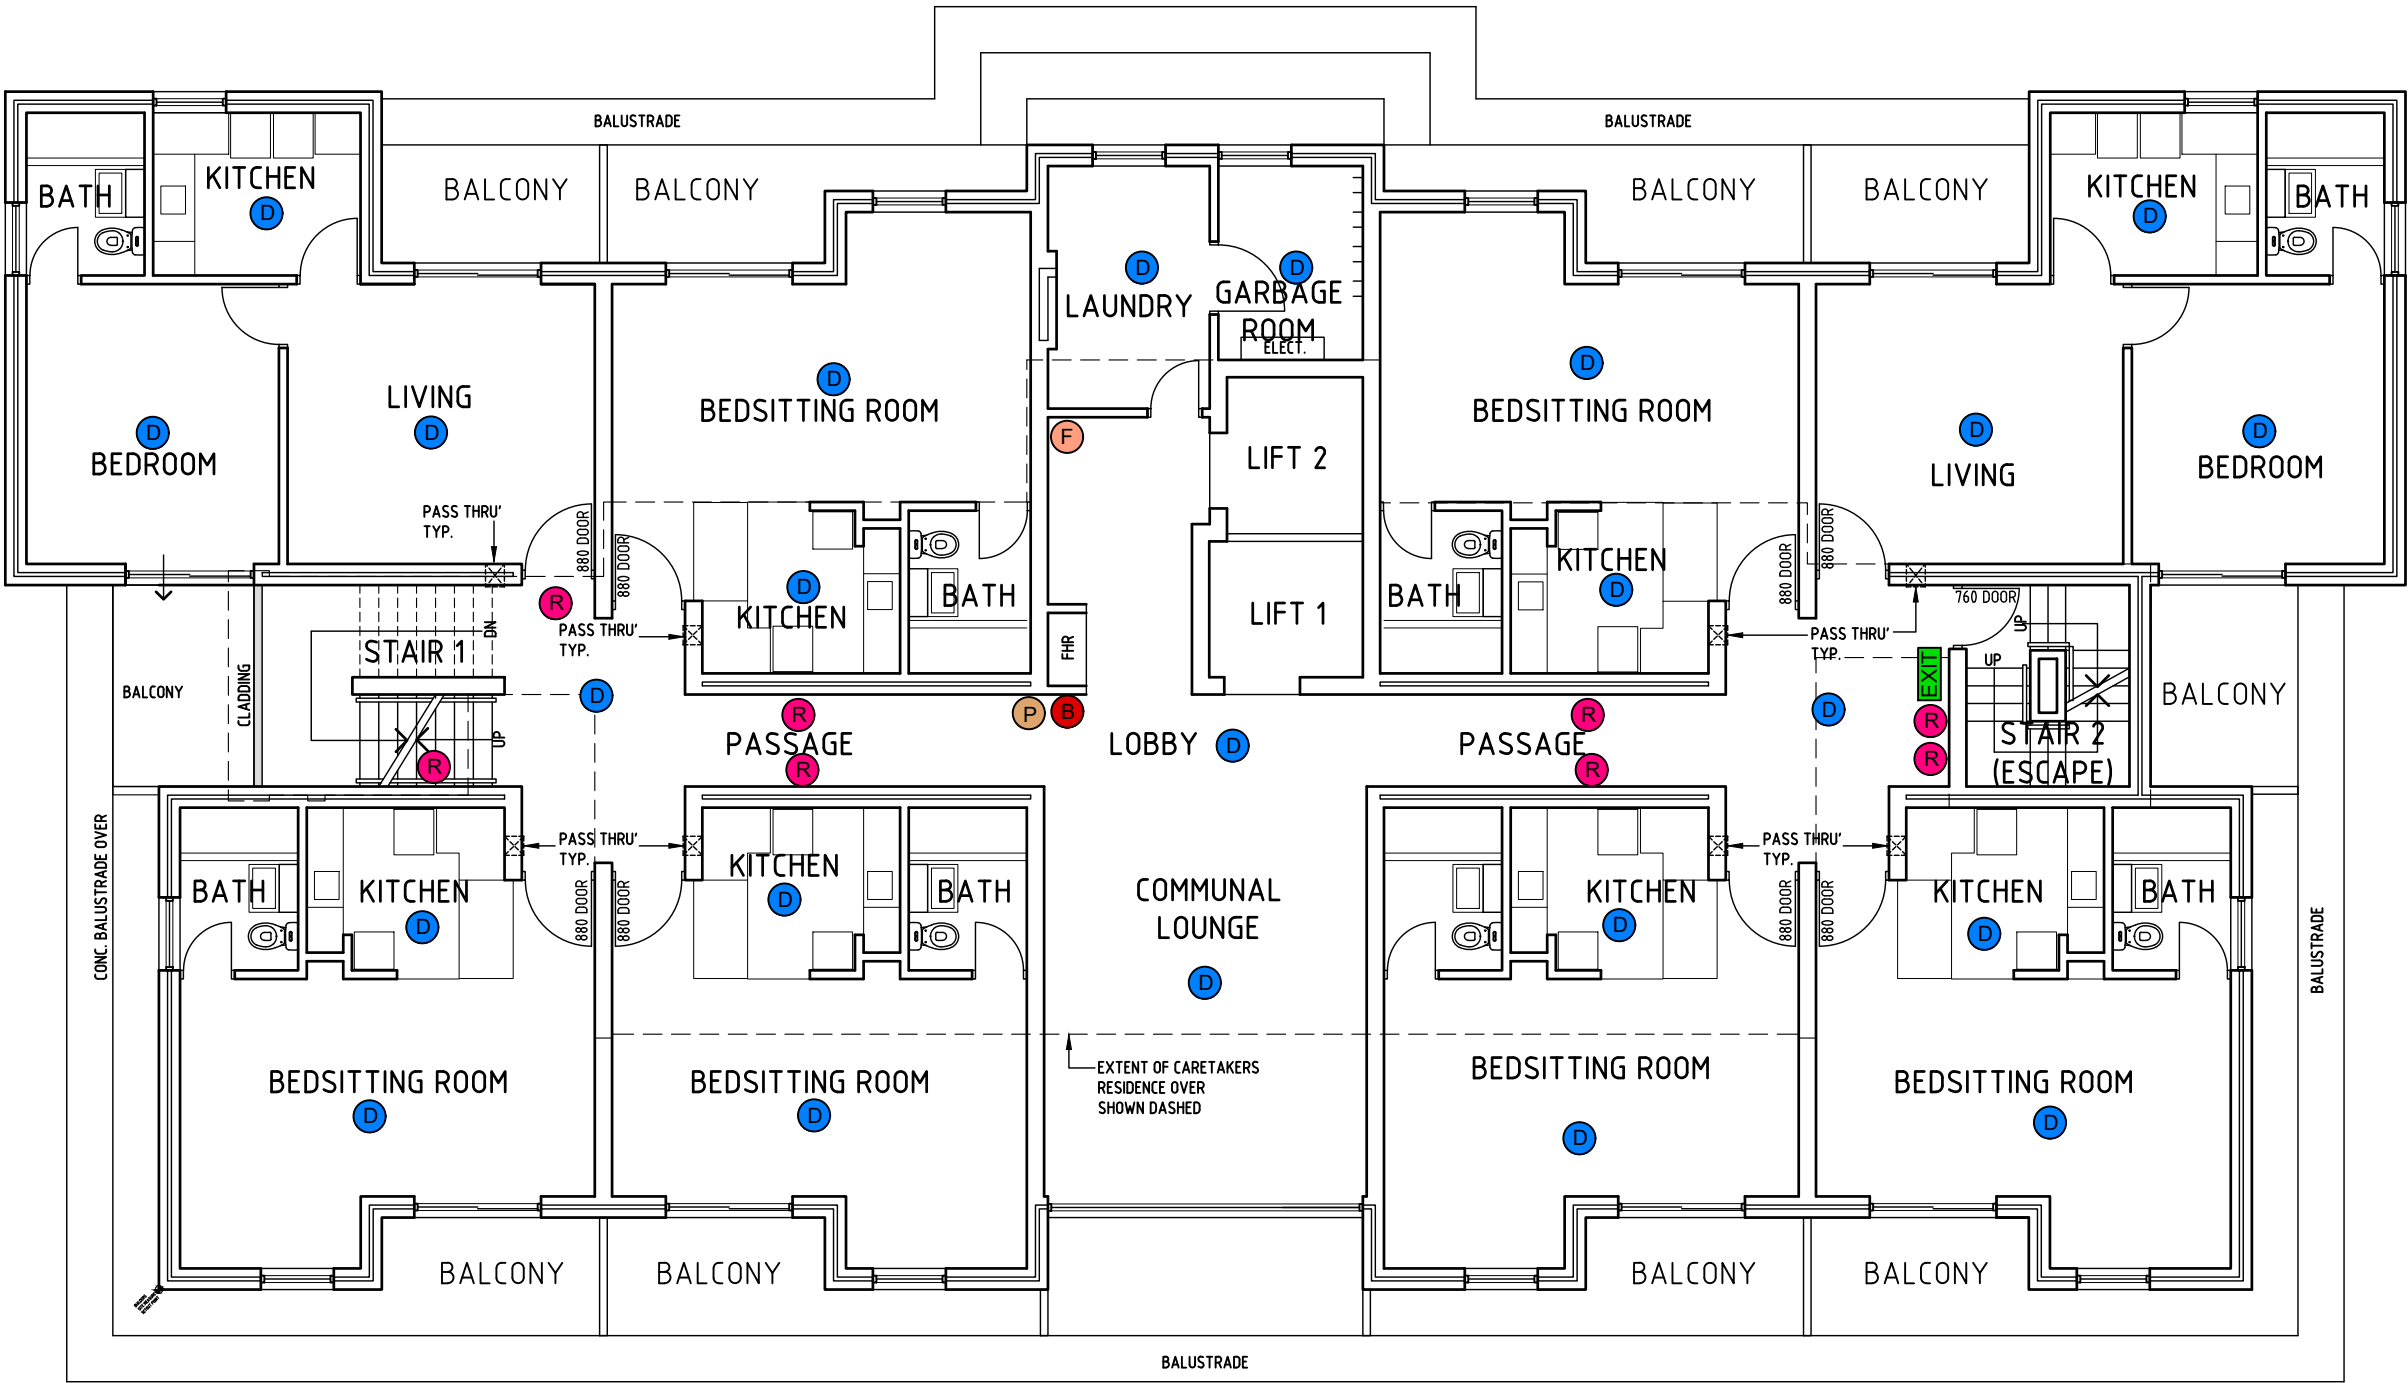

Floor Plan Level 4

 scale 1:100

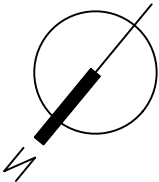

NOTE:
THESE FIRE SERVICES AS CONSTRUCTED
ARCHITECTURAL DRAWINGS ARE SUBJECT
TO FIRE CONSULTANT/S REVIEW DOCUMENTATION

PRELIMINARY DRAWING
NOT FOR CONSTRUCTION

AS CONSTRUCTED
AS AT 22.02.2024

NOTE:
THESE ARE CAD CONVERSION DRAWINGS
FROM IMPERIAL AND ARE
NOT TO BE USED FOR
CONSTRUCTION PURPOSES

REV	DESCRIPTION	DATE

VISTA DESIGNS
Building Designers

SUITE 3, 279 LORD STREET
EAST PERTH 6004
TEL./FAX: 922771415
© COPYRIGHT

SWAN CARE RICHARD CLEAVER LODGE
34 Graham Cres,
BENTLEY WA 6102

Drawing Title
Existing Level 4
Fire Services


Drawn	Scale	Date	Job No.	Drawing No.	Rev
	1:100, BAZ	01.10.25	3097	FS5 of 8	-

NOTE:
MEASURE & CHECK ALL DIMENSIONS
ON SITE TO CONFIRM LAYOUT PRIOR TO
CONSTRUCTION

NOTE:
NOMINATED DOOR WIDTH SHOWN ON PLAN
ARE NOMINAL SIZES ONLY.
ALL NOMINATED DOOR WIDTHS & MATERIALS
SHALL BE VERIFIED ON SITE.



EXISTING SERVICES LEGEND

- B ALARM BELL.
- D DETECTOR
- EXIT EXIT SIGN
- F FIRE EXTINGUISHER (3.5kg / CO2)
- P EXIT PLAN
- R FIRE ALARM IN ROOM INDICATOR

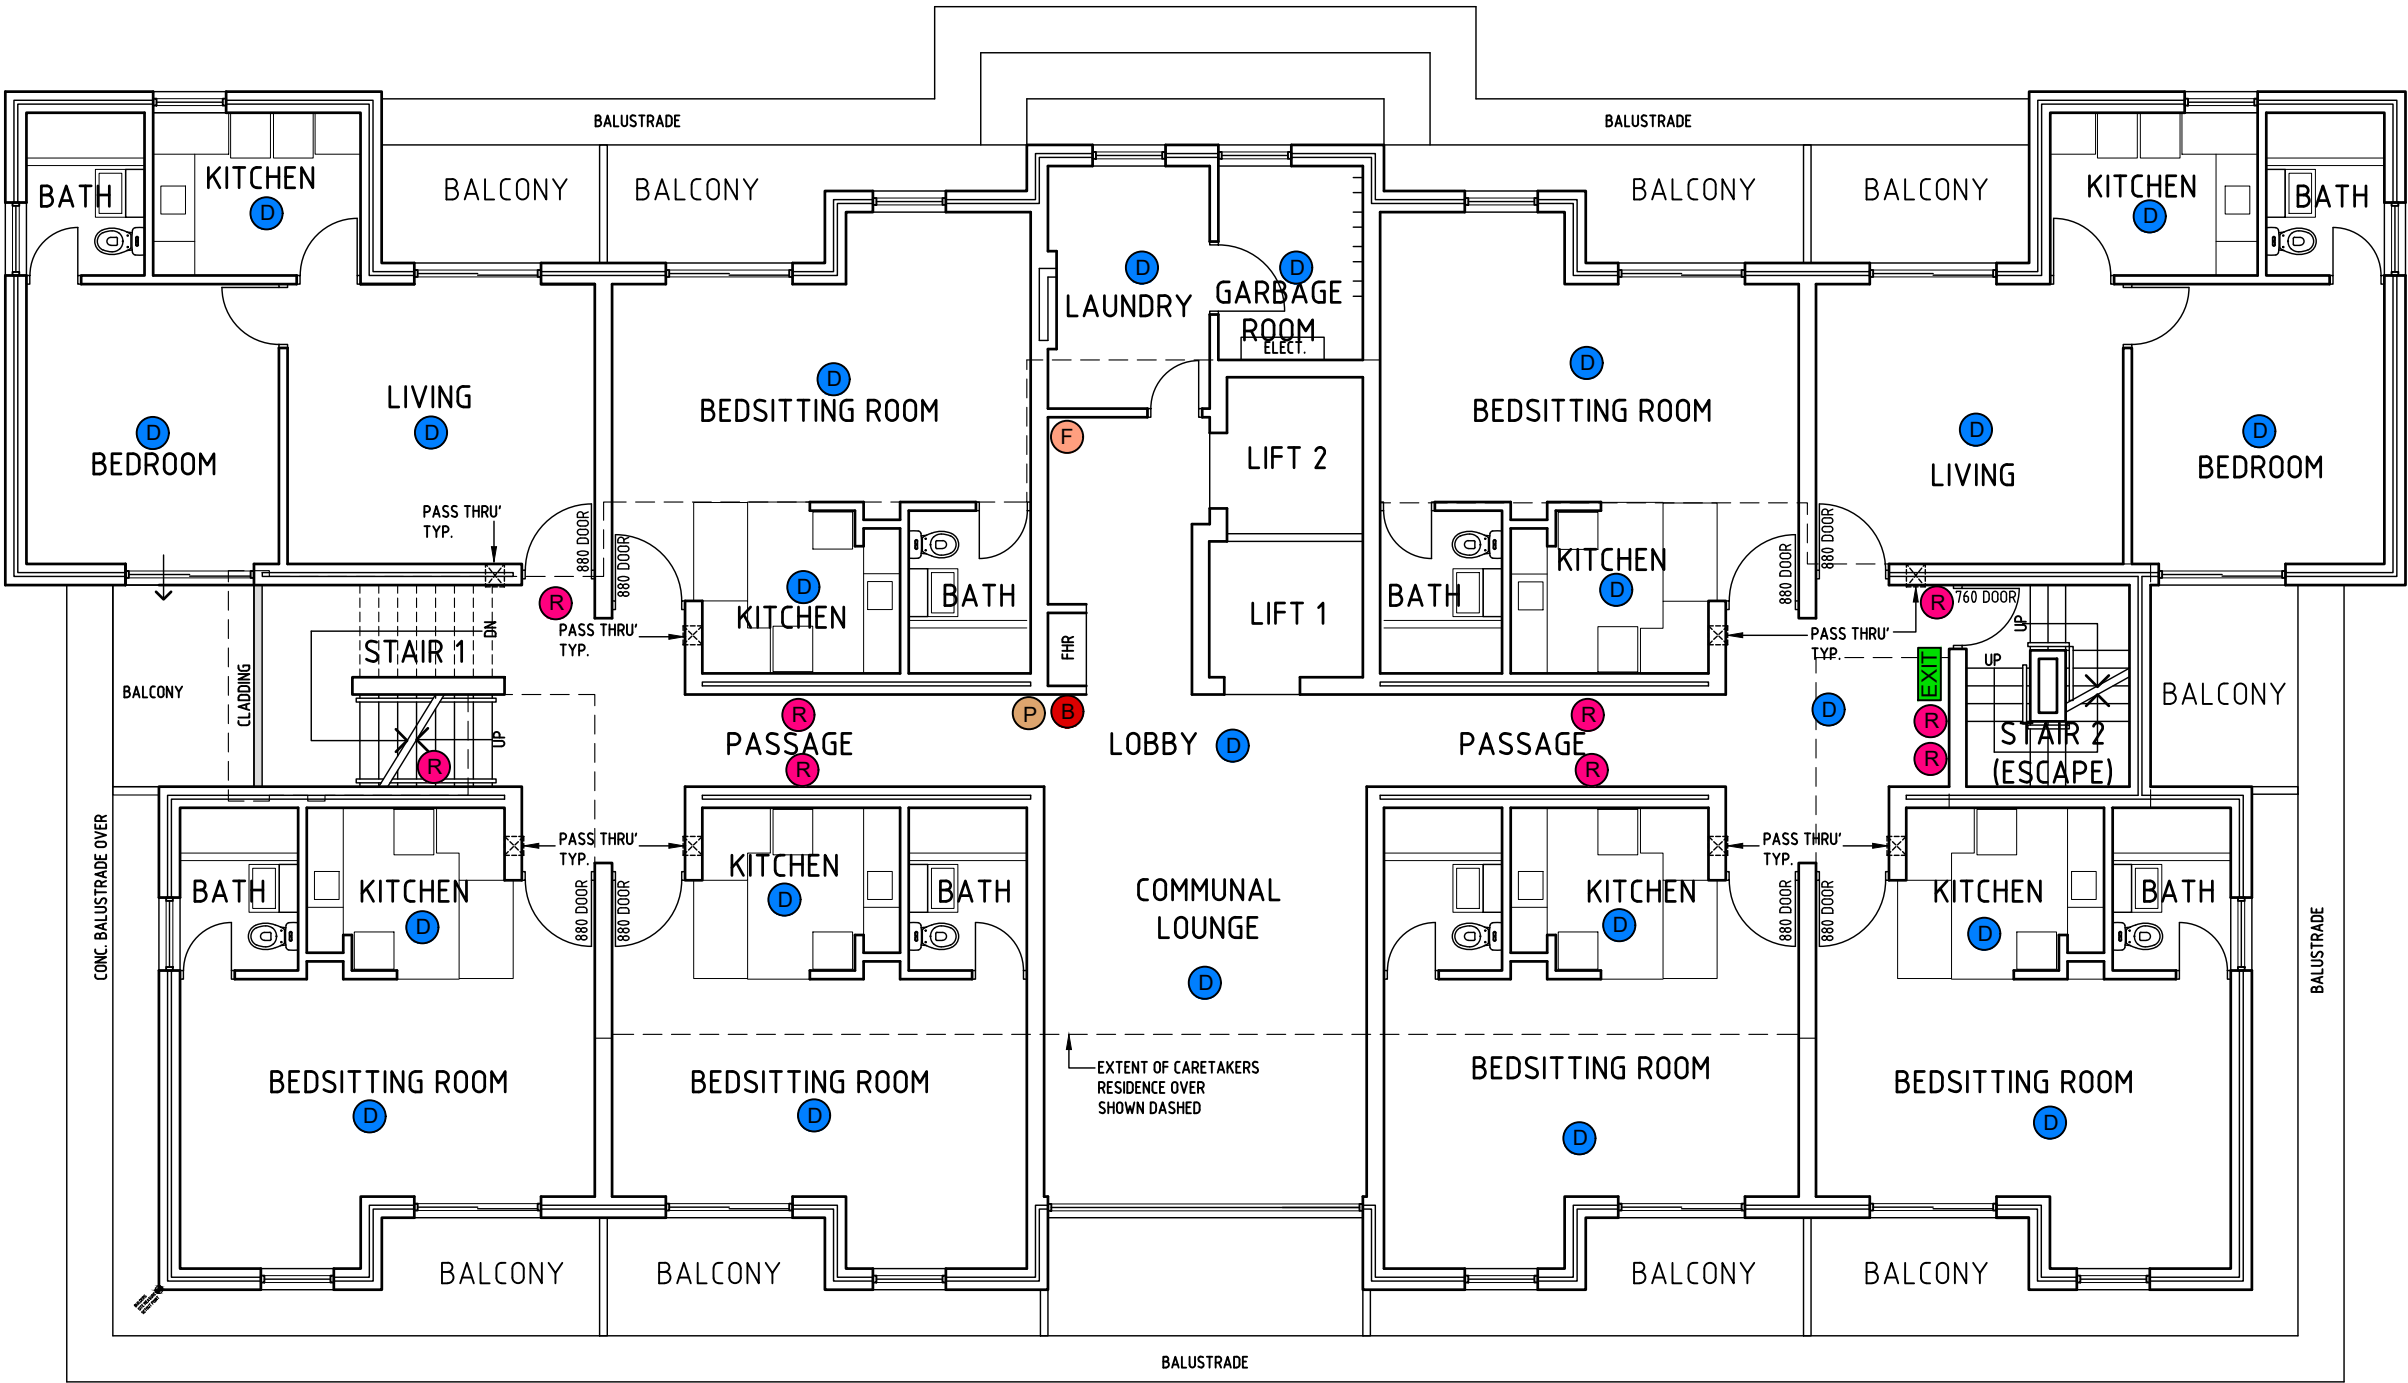

Floor Plan Level 5

 scale 1:100

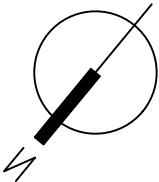

NOTE:
THESE FIRE SERVICES AS CONSTRUCTED
ARCHITECTURAL DRAWINGS ARE SUBJECT
TO FIRE CONSULTANT/S REVIEW DOCUMENTATION

PRELIMINARY DRAWING
NOT FOR CONSTRUCTION

AS CONSTRUCTED
AS AT 22.02.2024

NOTE:
THESE ARE CAD CONVERSION DRAWINGS
FROM IMPERIAL AND ARE
NOT TO BE USED FOR
CONSTRUCTION PURPOSES

REV	DESCRIPTION	DATE
-	-	-

VISTA DESIGNS
Building Designers

SUITE 3, 279 LORD STREET
EAST PERTH 6004
TEL./FAX: 922771415
© COPYRIGHT

SWAN CARE RICHARD CLEAVER LODGE
34 Graham Cres,
BENTLEY WA 6102

Drawing Title
Existing Level 5
Fire Services


Drawn	Scale	Date	Job No.	Drawing No.	Rev
1/100, BAZ	01.10.25	3097		FS6 of 8	-

NOTE:
MEASURE & CHECK ALL DIMENSIONS
ON SITE TO CONFIRM LAYOUT PRIOR TO
CONSTRUCTION

NOTE:
NOMINATED DOOR WIDTH SHOWN ON PLAN
ARE NOMINAL SIZES ONLY.
ALL NOMINATED DOOR WIDTHS & MATERIALS
SHALL BE VERIFIED ON SITE.



EXISTING SERVICES LEGEND

- B ALARM BELL.
- D DETECTOR
- EXIT EXIT SIGN
- F FIRE EXTINGUISHER (3.5kg / CO2)
- P EXIT PLAN
- R FIRE ALARM IN ROOM INDICATOR

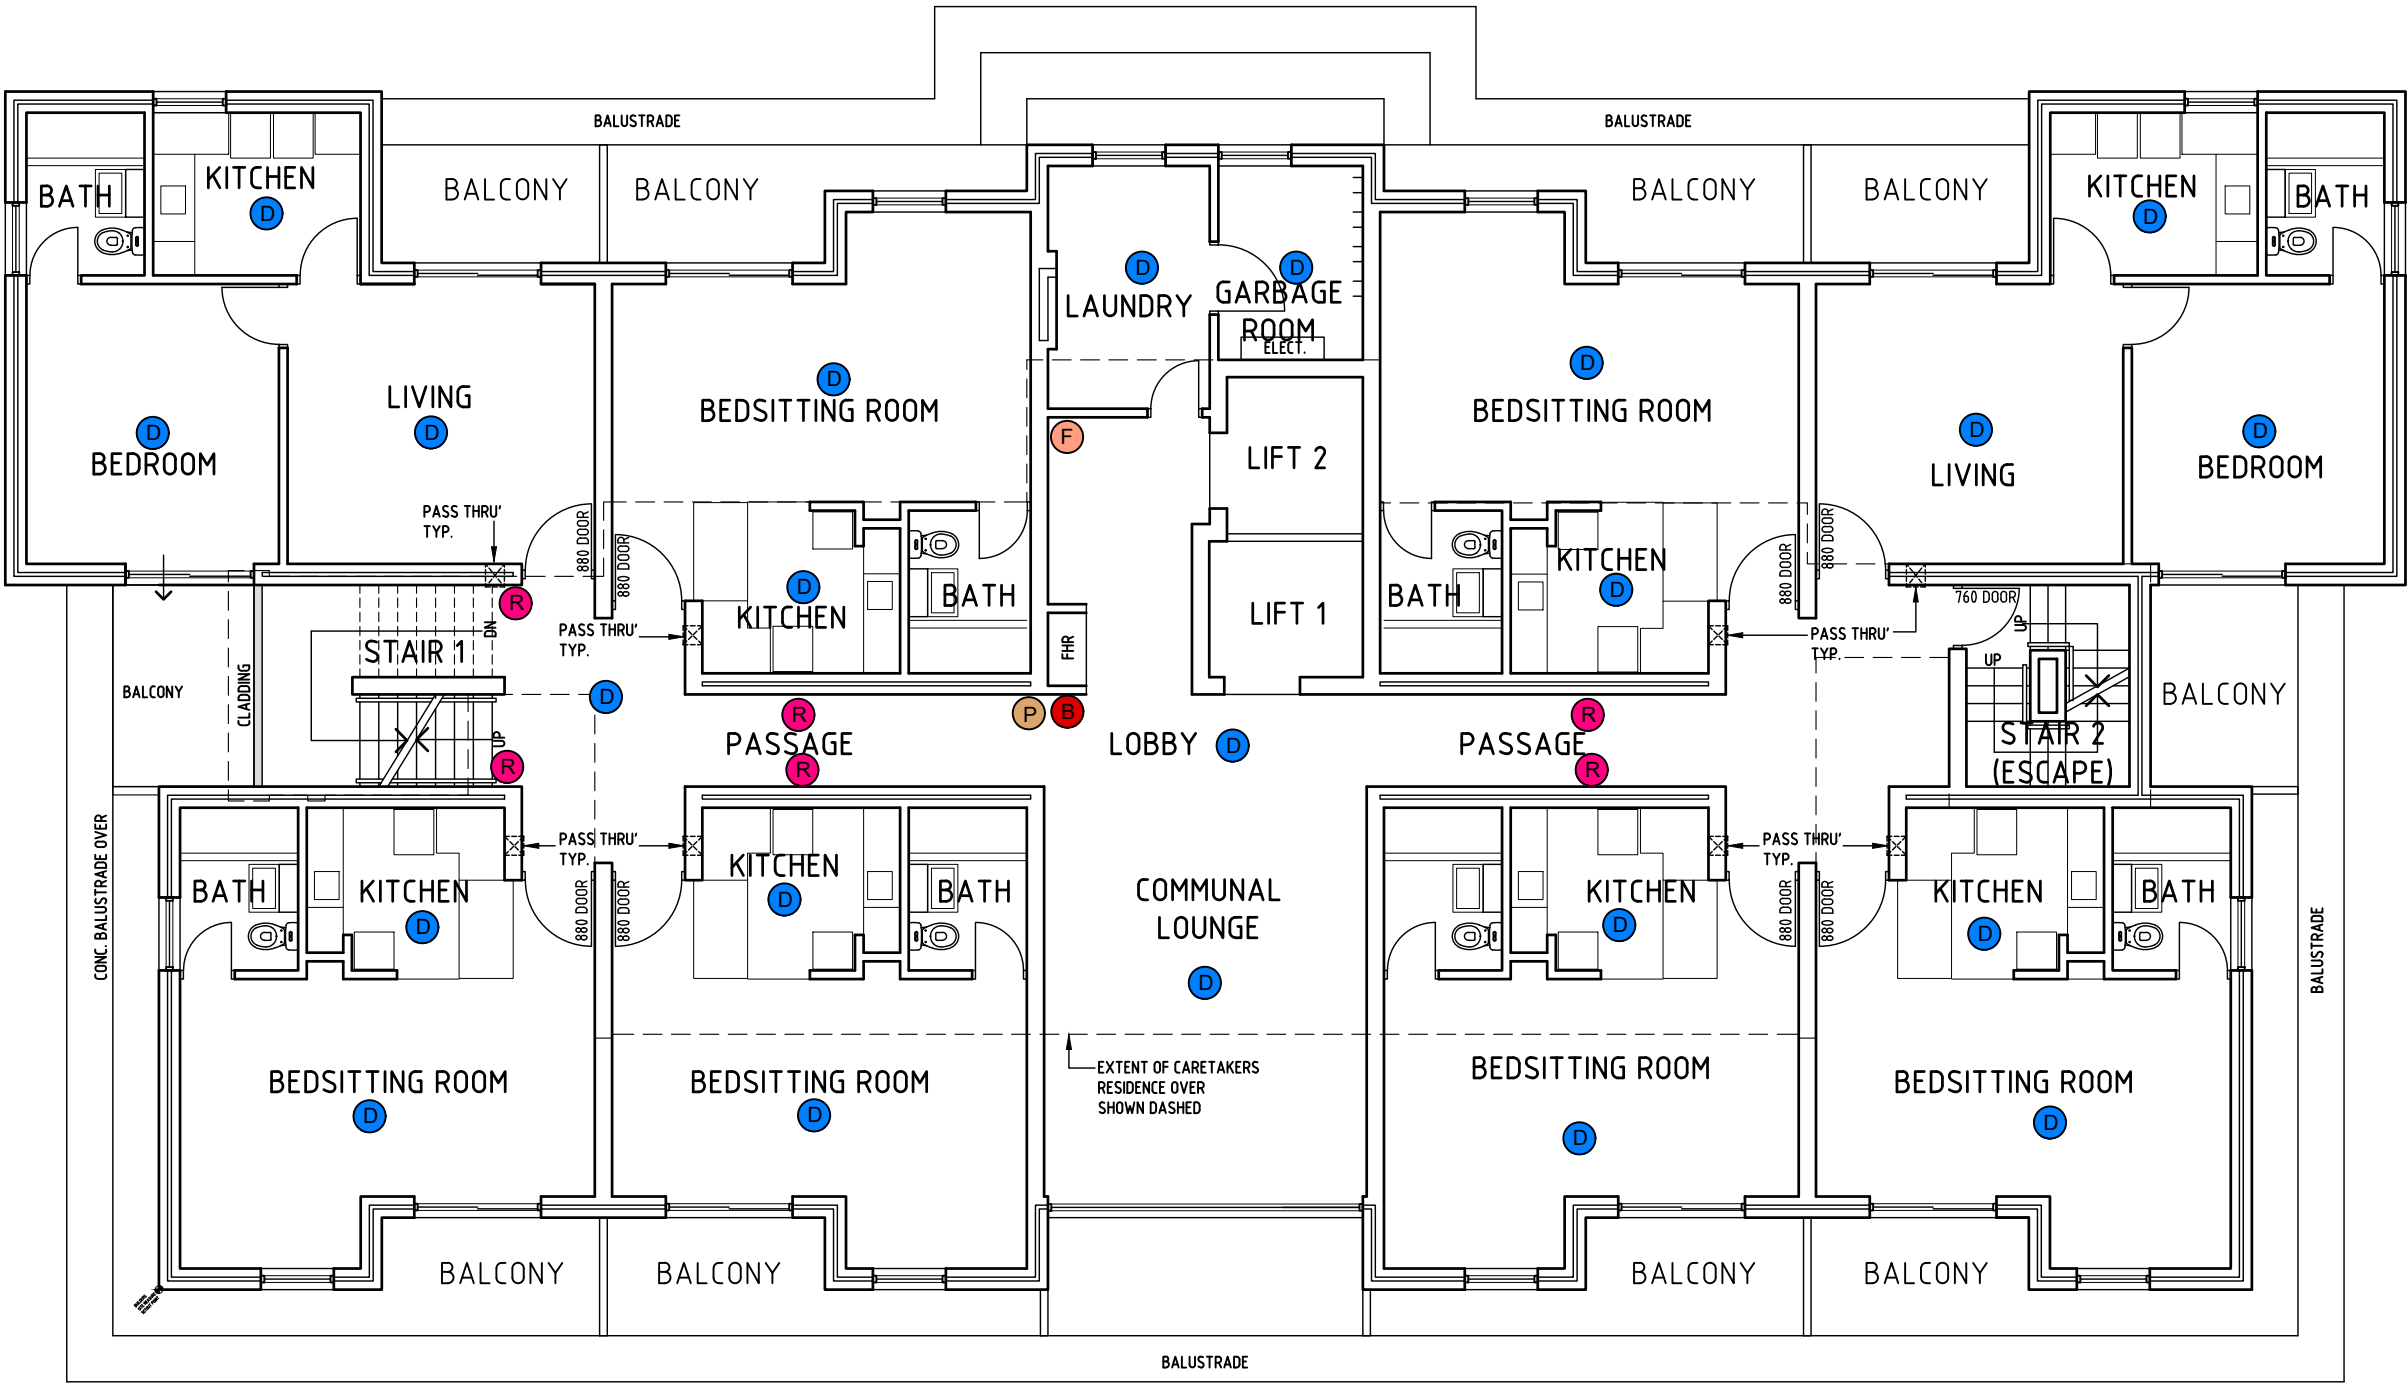

Floor Plan Level 6

 scale 1:100

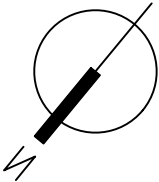

NOTE:
THESE FIRE SERVICES AS CONSTRUCTED
ARCHITECTURAL DRAWINGS ARE SUBJECT
TO FIRE CONSULTANT/S REVIEW DOCUMENTATION

PRELIMINARY DRAWING
NOT FOR CONSTRUCTION

AS CONSTRUCTED
AS AT 22.02.2024

NOTE:
THESE ARE CAD CONVERSION DRAWINGS
FROM IMPERIAL AND ARE
NOT TO BE USED FOR
CONSTRUCTION PURPOSES

REV	DESCRIPTION	DATE
-	-	-

VISTA DESIGNS
Building Designers

SUITE 3, 279 LORD STREET
EAST PERTH 6004
TEL./FAX: 92277415
© COPYRIGHT

SWAN CARE RICHARD CLEAVER LODGE
34 Graham Cres,
BENTLEY WA 6102

Drawing Title
Existing Level 6
Fire Services

Drawn	Scale	Date	Job No.	Drawing No.	Rev
	1:100, BAZ	01.10.25	3097	FS7 of 8	-



NOTE:
MEASURE & CHECK ALL DIMENSIONS
ON SITE TO CONFIRM LAYOUT PRIOR TO
CONSTRUCTION

Check all dimensions on site prior to commencement of any works.
Unauthorised copying or distribution of this drawing is strictly
prohibited. Copyright © 2023

NOTE:
NOMINATED DOOR WIDTH SHOWN ON PLAN
ARE NOMINAL SIZES ONLY.
ALL NOMINATED DOOR WIDTHS & MATERIALS
SHALL BE VERIFIED ON SITE.

EXISTING SERVICES LEGEND

- B ALARM BELL.
- D DETECTOR
- EXIT EXIT SIGN
- F FIRE EXTINGUISHER (3.5kg / CO2)
- P EXIT PLAN
- R FIRE ALARM IN ROOM INDICATOR

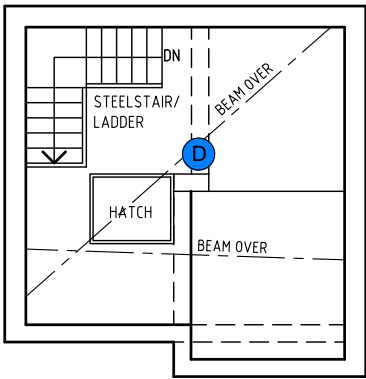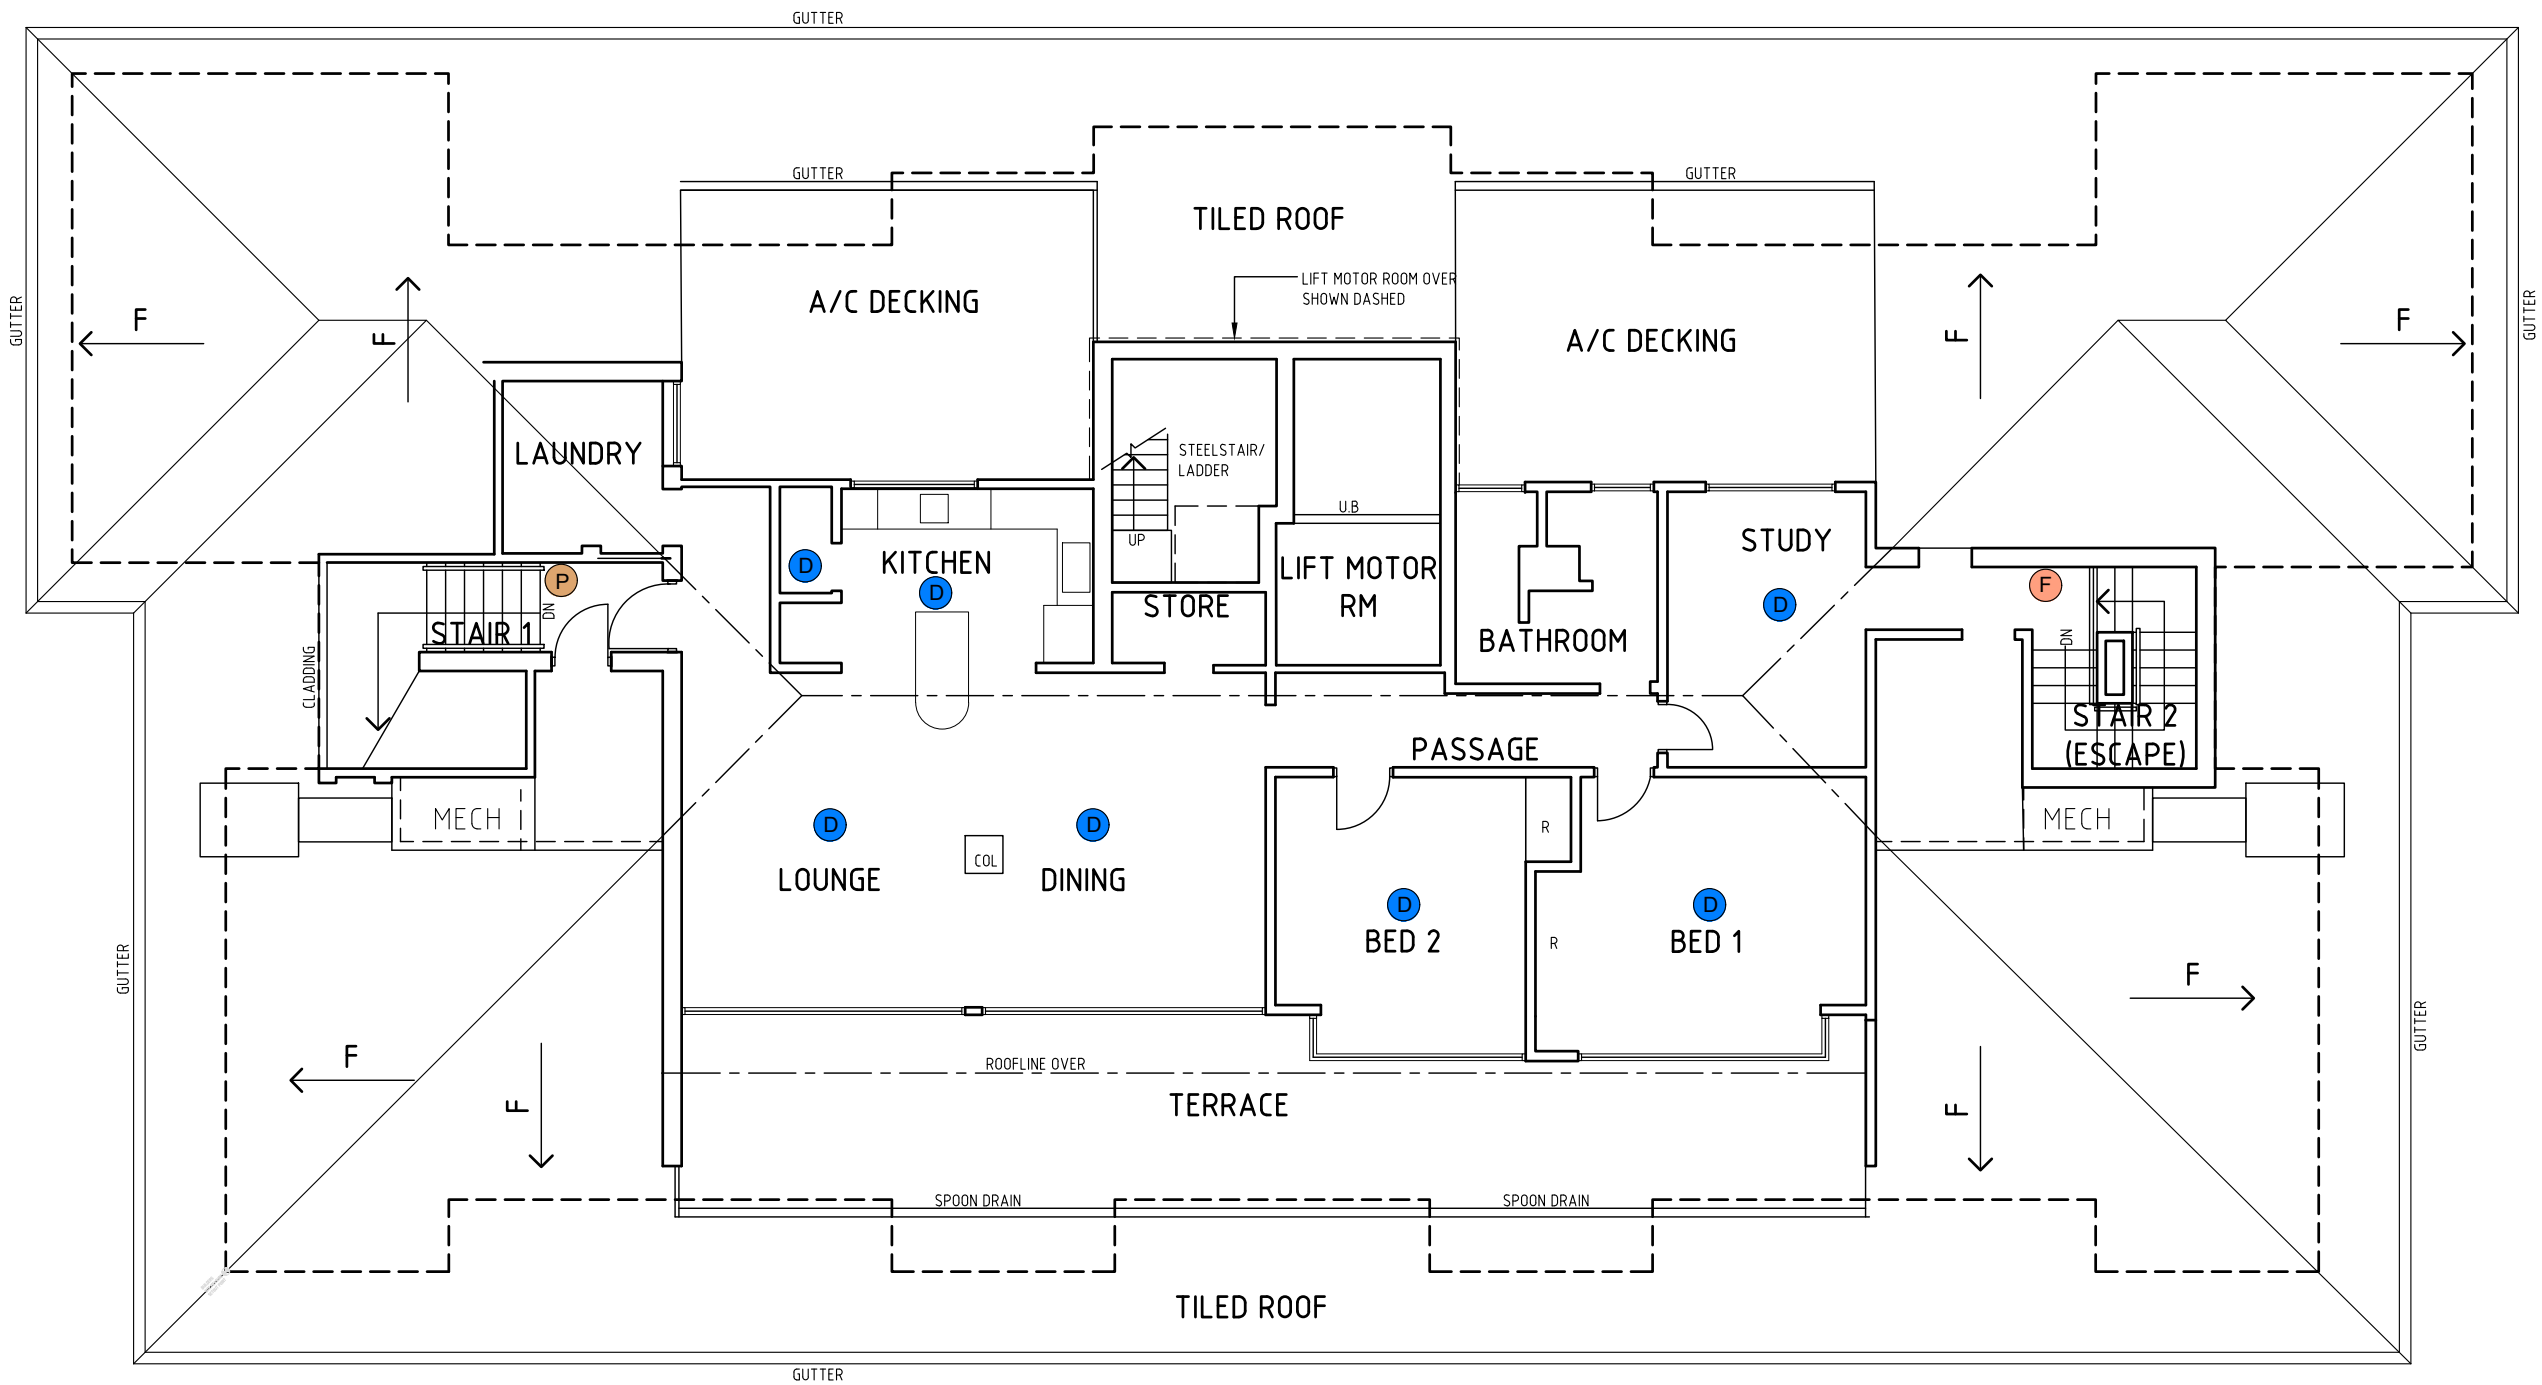



Lift Motor Room
Floor plan

scale 1:100

NOTE:
THESE FIRE SERVICES AS CONSTRUCTED
ARCHITECTURAL DRAWINGS ARE SUBJECT
TO FIRE CONSULTANT/S REVIEW DOCUMENTATION

Caretakers Residence - Existing Floor Plan

 scale 1:100

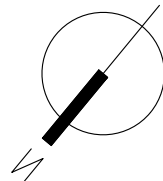

NOTE:
MEASURE & CHECK ALL DIMENSIONS
ON SITE TO CONFIRM LAYOUT PRIOR TO
CONSTRUCTION

VISTA DESIGNS
Building Designers
SUITE 3, 279 LORD STREET
EAST PERTH 6004
TEL./FAX: 92277415
© COPYRIGHT

PRELIMINARY DRAWING
NOT FOR CONSTRUCTION

AS CONSTRUCTED
AS AT 22.02.2024

NOTE:
THESE ARE CAD CONVERSION DRAWINGS
FROM IMPERIAL AND ARE
NOT TO BE USED FOR
CONSTRUCTION PURPOSES

REV	DESCRIPTION	DATE

SWAN CARE RICHARD CLEAVER LODGE 34 Graham Cres, BENTLEY WA 6102			
Drawing Title Existing Caretakers Residence Fire Services			
Drawn	Scale 1:100, BAZ	Date 09.10.25	Job No. 3097
Drawing No.	Rev		
FS8 of 8	-		