



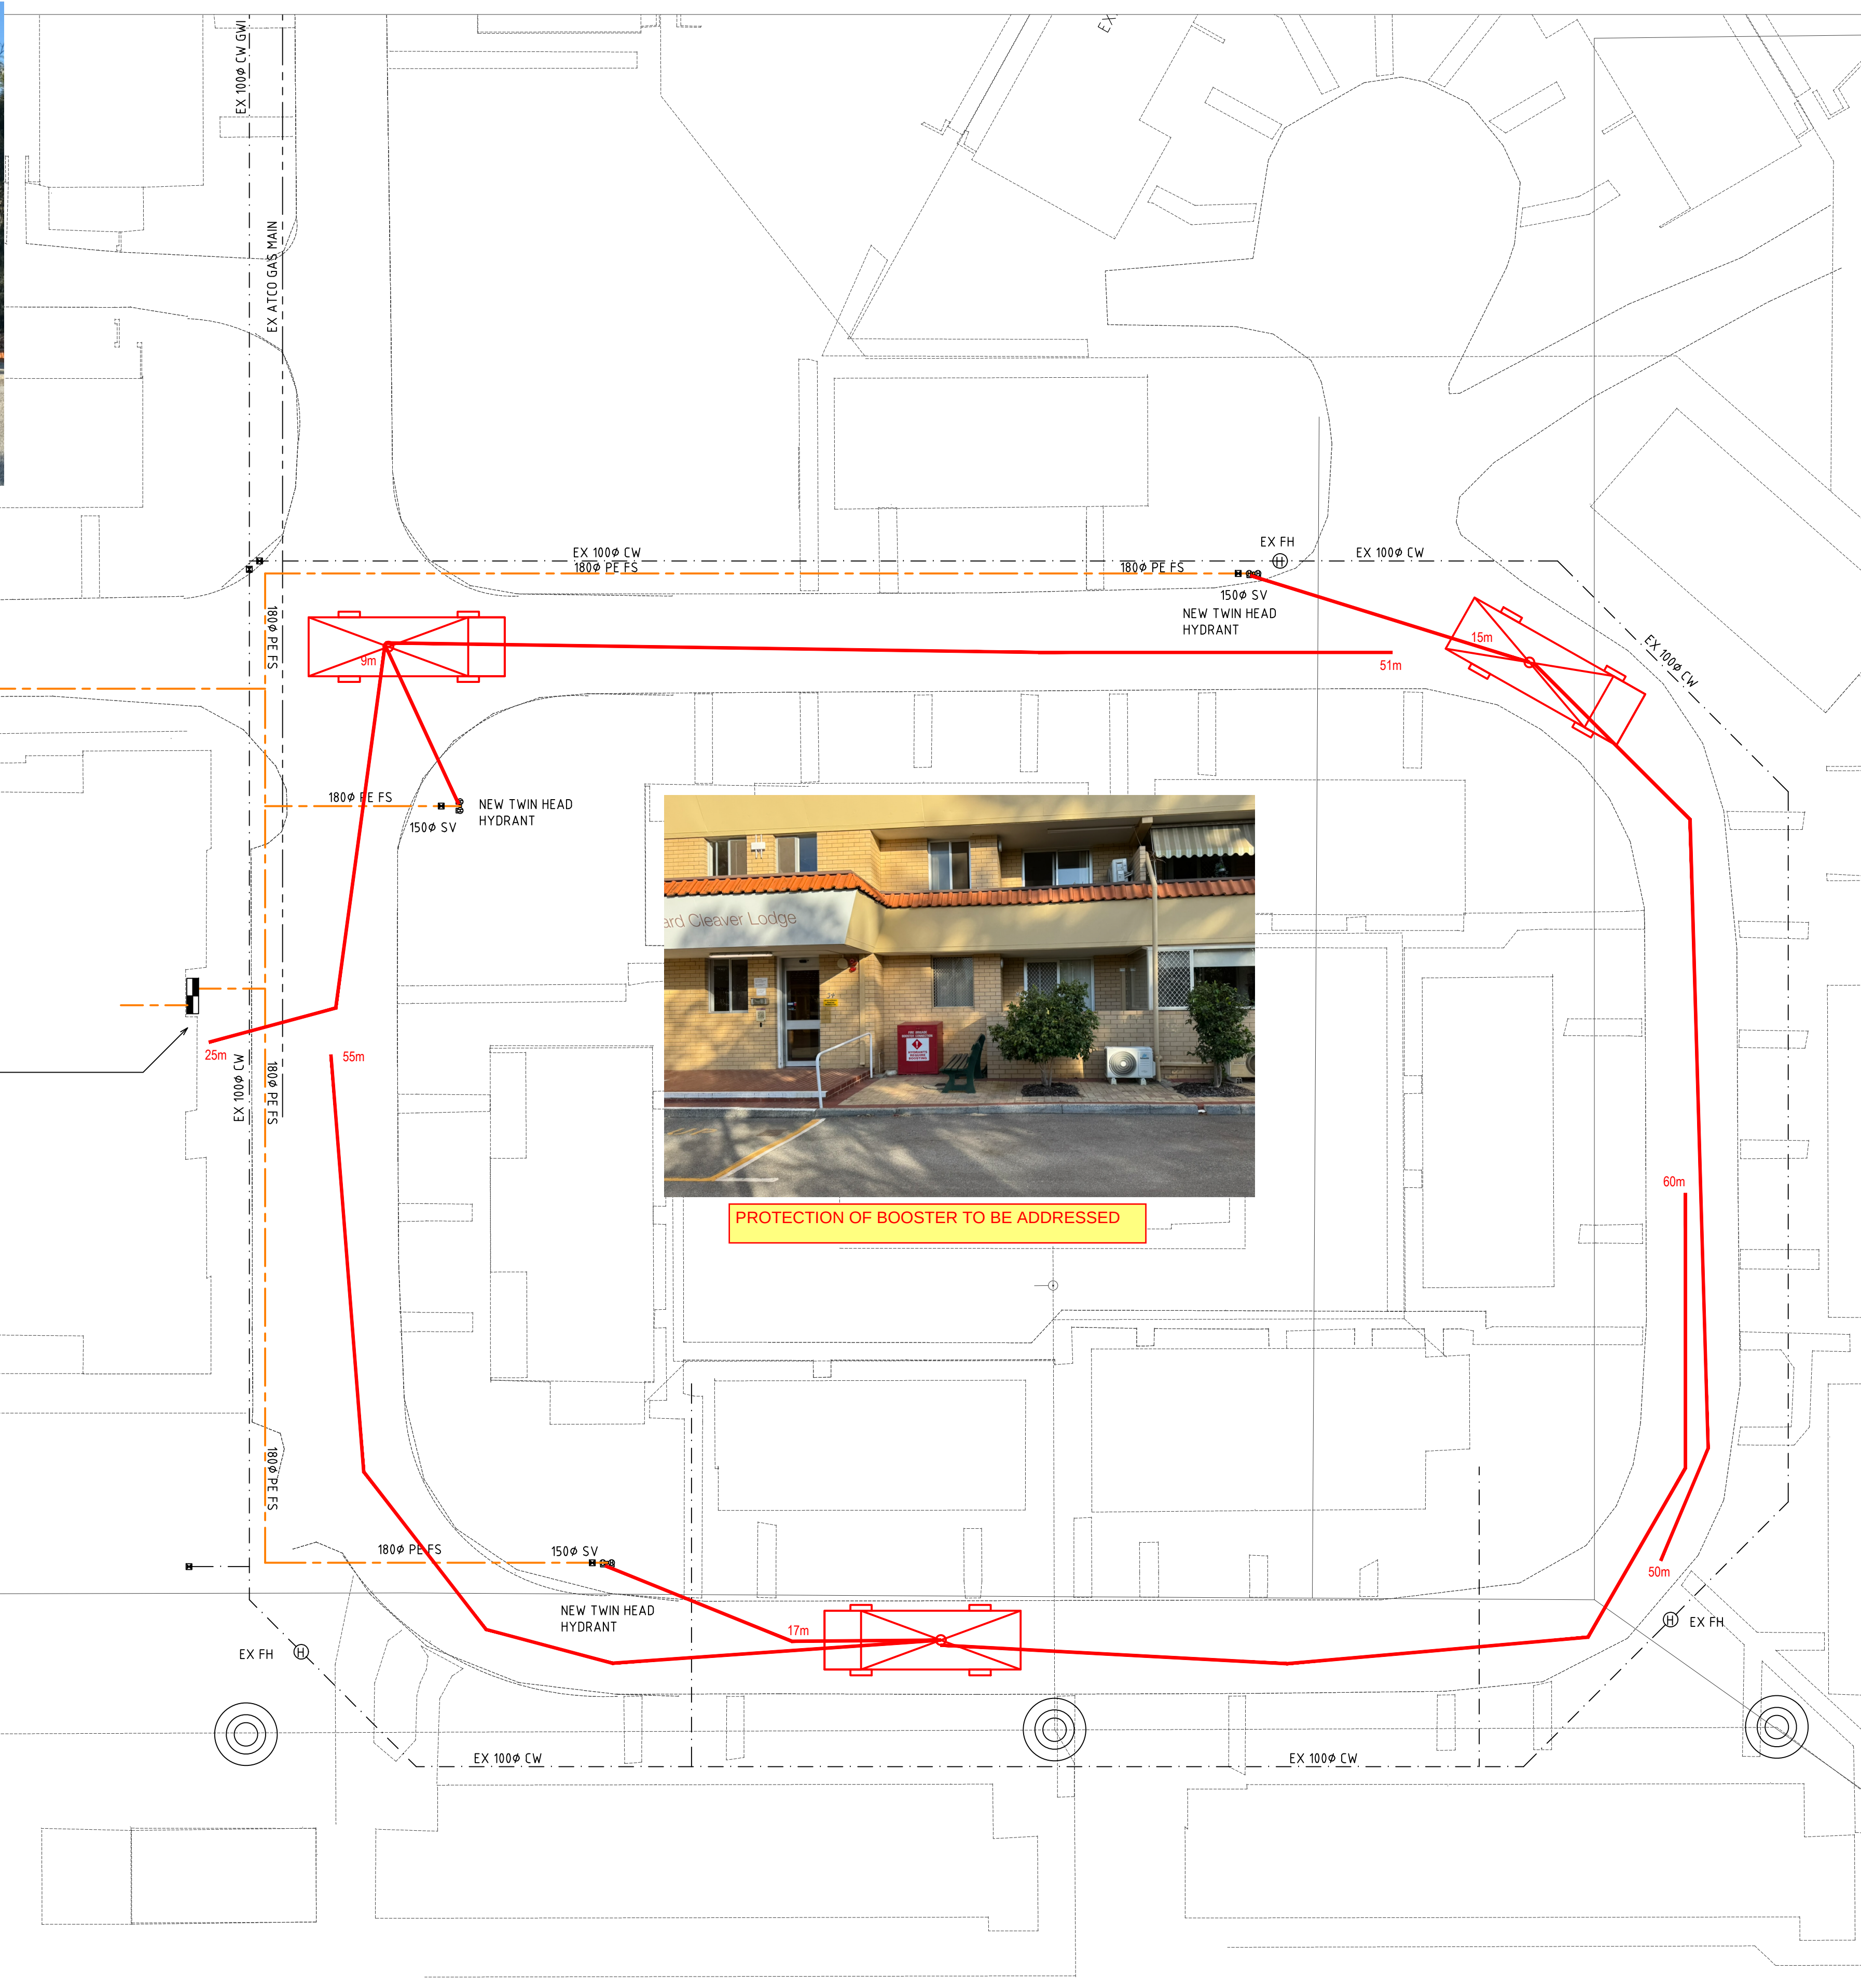

AUTHORITY SEWER	Blue
AUTHORITY WATER	Light Blue
AUTHORITY GAS	Light Green
WATER SERVICE	Dark Blue
HEATED WATER SERVICE	Dark Green
HEATED WARM WATER	Orange
GAS SERVICE	Yellow
FIRE SERVICE	Red
NON POTABLE WATER	Purple
REFLECTED PIPEWORK	Grey
SOL PIPE	Light Blue
STORMWATER	Magenta
VENT PIPE	Light Green
WASTE PIPE	Dark Green
TRADE WASTE	Dark Blue
MECHANICAL DRAIN	Dark Green
CHENG MAIN	Dark Green

AIR ADMITTANCE VALVE	⊕	FLOOR WASTE/GULLY	⊖	DISCONNECTOR GULLY DOWNSISER
BACKFLIGHT	⊕	FLOOR WASTE BOX	⊖	DRISER
BREAK POINT	⊕	INSPECTION OPENING	⊖	SLEEVED PIPE
CAPPED/PLUGGED PIPE	⊕	LOCATION VALVE	⊖	SOIL/WASTE STACK
CLEANOUT	⊕	N IN V BOX	⊖	STOP P
CLEANOUT IN V BOX	⊕	METER	⊖	STOP P
CONTINUATION	⊕	NO RETURN VALVE	⊖	STRAINER
DISCONNECTOR GULLY	⊕	PRESSURE LIMITING/REL VALVE	⊖	TRAP PRIMER
DOWN PIPE SUMP BOX	⊕	PUMP	⊖	TUNDSH
DRAIN	⊕	REDUNDANT PIPE	⊖	VENT PIPE RISER
FIRE HYDRANT	⊕	REGULATOR	⊖	VENT FIRE HOSE RISER
DROPPER	⊕	REFLEX VALVE	⊖	ACCESS PANEL
FILTER	⊕		⊖	

AK	ASBESTOS	ID	INSPECTION OPENING
AL	ASSIGNMENTS	IS	INSPECTION SHAF
AM	ATTACH PANEL	ISB	INDUSTRIAL WASTE
AN	ABLUTION TROUGH	ISW	INDUSTRIAL WASTE TRAP
AO	ATCO GAS	ISWP	INDUSTRIAL WASTE SAMPLE POINT
AP	APPROVE FLOOR LEVEL	ISX	IN CAVITY
AR	ARM AMBIENT WATER VALVE	IV	IN GROUND
AS	AROMATIC WATER CLOSET	IVG	ISOLATION VALVE
AT	BALCONY DRAIN	J	JUMP UP
AV	BUCKET TRAP	KS	KITCHEN SINK
AW	BOILING WATER TRAP	LS	LAR SINK
AX	WALL VALVE	LX	LAUNDRY TROUGH
AY	CONDENSATE DRAIN	MB	METER BOX
BA	COLD HOT WATER	MH	MANHOLE
BB	COLD T EMPERED WATER	ME	MEDIUM DENSITY POLY ETHYLENE
BC	CLEANERS SINK	MP	METER
BD	COPPED MACHINE	N	NOT POTABLE COLD WATER
BE	CLEAN OUT	NG	NATURAL GAS
BF	CHROME PLATED	NO	OVERFLOW
BG	CEILING CUPAL	OW	ON WALL
BH	COPPER	OF	OVERFLOW RIGID GULLY
BI	CHILLED BOILING WATER DRINKING UNIT	OP	PAVING DRAIN
BJ	CONNECTOR GULLY	PE	POLY ETHYLENE
BK	DISCONNECTOR GULLY	PT	PRACTICAL TROUGH
BL	DOUBLE GAS TUBET	PS	PRESSURE RESISTANT
BM	DRAIN SUMP BOX	PS	PROPERTY SEWER
BN	DRINKING FOUNTAIN	PSMH	PROPERTY SEWER MANHOLE
BO	DRAIN SPUR	RA	RAN WATER PIPE
BP	DRINK CHECK VALVE	RF	REFLECT POINT
BQ	EXHAUSTIVE COOLER	RPD	REDUCED PRESSURE DEVICE
BR	EMERGENCY SAFETY SHUTOFF	RPS	RIGIDS SHAF CLEAN OUT
BS	EYE WASH	RV	REFLUX VALVE
BT	EXISTING	SE	SEALED INDUSTRIAL WASTE SAMPLE POINT
BV	FLOOR DRAIN	SP	SINK PIPE
BW	FIRE SERVICE	SV	SUUCE VALVE
BX	FIRE HYDRANT	SW	STORM WATER
BY	FLOOR WASTE GULLY	SK	SINK (CONNECT ONLY)
BZ	FLUSH SERVICE	SH	SHOWER
CA	FINISHED SURFACE LEVEL	TH	TUNDISH
CB	FLASHING HRP	THV	THEMOSTATIC MIXING VALVE
CC	FLASH ANGLE UNIT	TV	TEMPERED WATER
CD	FORWARD WORKS	U	UNDER SLAB
CE	GRATED CHANNEL	UW	UNIVERSAL WALL BASIN
CF	GAS ROOM HEATER	USB	UNIVERSAL SHAF
CG	GRAND FLOOR LEVEL	UWC	UNIVERSAL WATER CLOSET
CH	HANDS FREE WALL BASIN	V	VANITY BASIN
CI	HOT WATER RETURN	V/BX	VALVE BOX
CJ	HOT WATER RETURN	VP	VENT PIPE
CK	HOT WATER RETURN	WP	WASTE PIPE
CL	HOT WATER RETURN	WB	WALL BASIN
CM	HOT WATER RETURN	WC	WATER CLOSET
CN	HOT WATER RETURN	WCM	WATER CLOSET WA
CO	HOT WATER RETURN	WV	WARM WATER

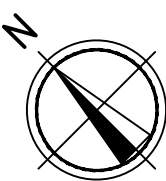

REV	DATE	DESCRIPTION	CHECK



1/300 FITZGERALD STREET PERTH WA 6000
Tel: (08) 9225 9300 Fax: (08) 9228 0933
Web: hdawa.com.au Email: info@hdawa.com.au

iredale pedersen hook architects

Perth Suite 8, Murray Mews 329-331 Murray Street, 6000,
PO Box 442 Leederville 6903 t 08 9322 9750 f 08 9322 9752
www.iredalepedersenhook.com email@iredalepedersenhook.com

RICHARD CLEAVER LODGE
PART SITE PLAN
FIRE SERVICE LAYOUT

DRAWN	CA	DESIGNED	SP	REDUCTION	
CHECKED	SP	PRINCIPAL		0	25
APPROVED	JT				
SCALE	1/200 @ A1	DATE	08.11.24	DRAWING No.	1
HDA PROJ No. 23144				H1.03	

THIS IS A CADD DRAWING
DO NOT AMEND MANUALLY

SHEET 3 OF 13







PART SITE PLAN
WATER, FIRE & GAS LAYOUT
SCALE 1:200 @ A1



FIRE ZONE BLOCK PLAN

SWAN CARE RICHARD CLEAVER LODGE

34 GRAHAM CRESCENT, BENTLY WA 6102

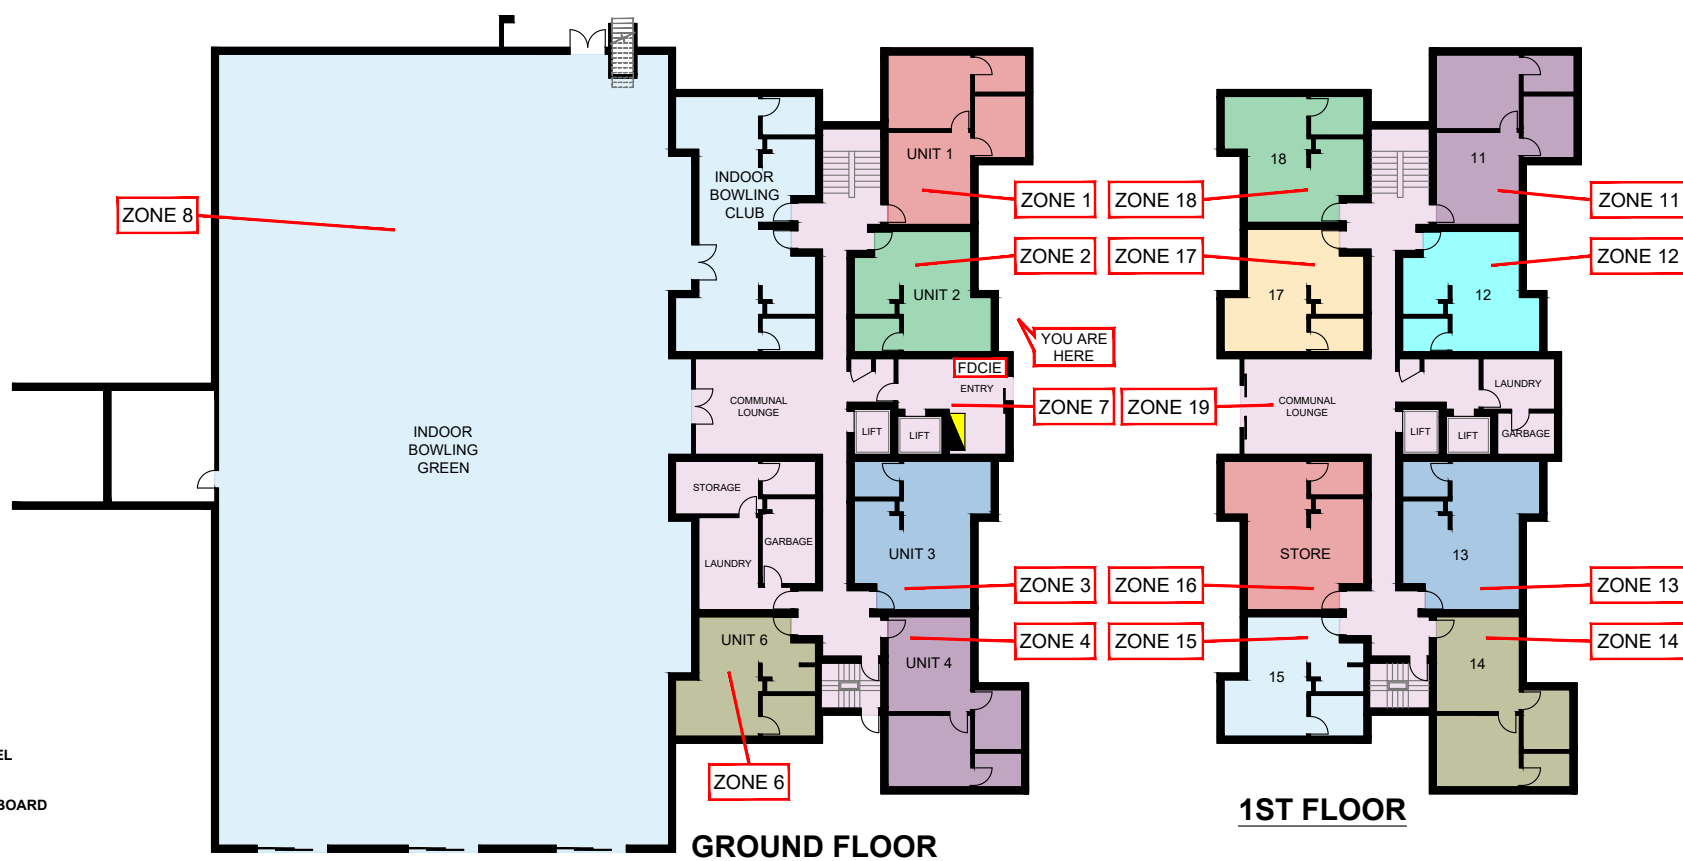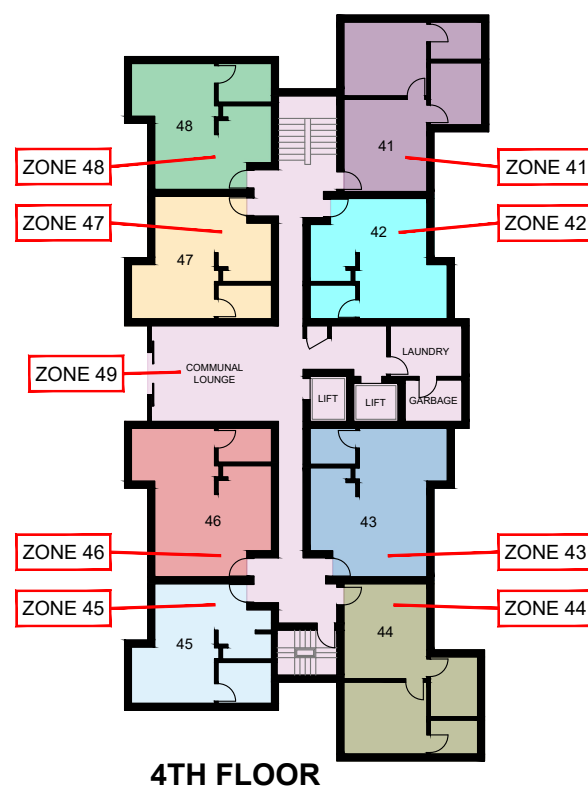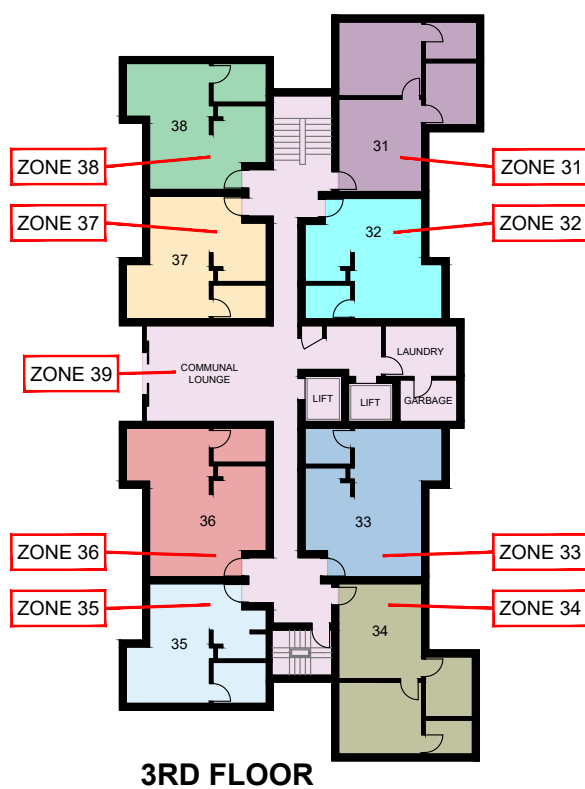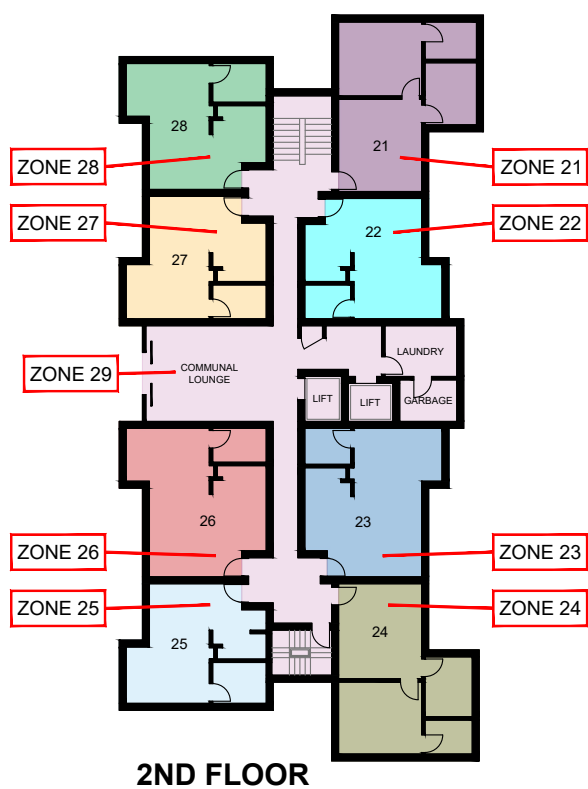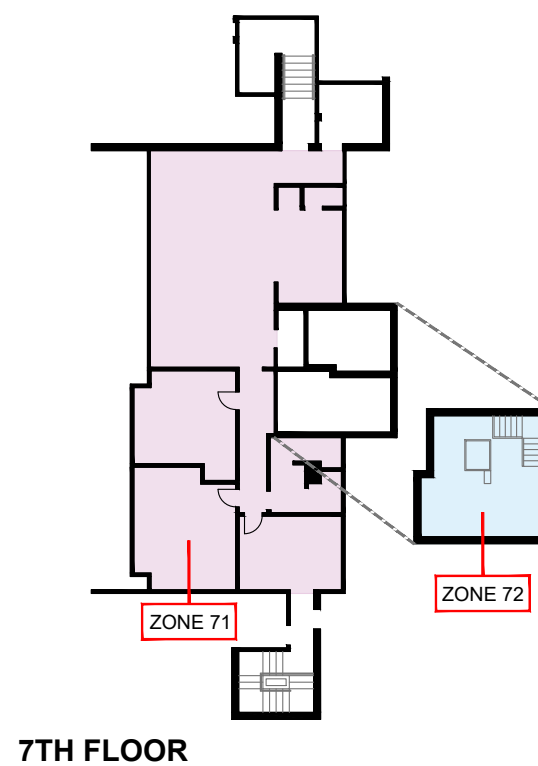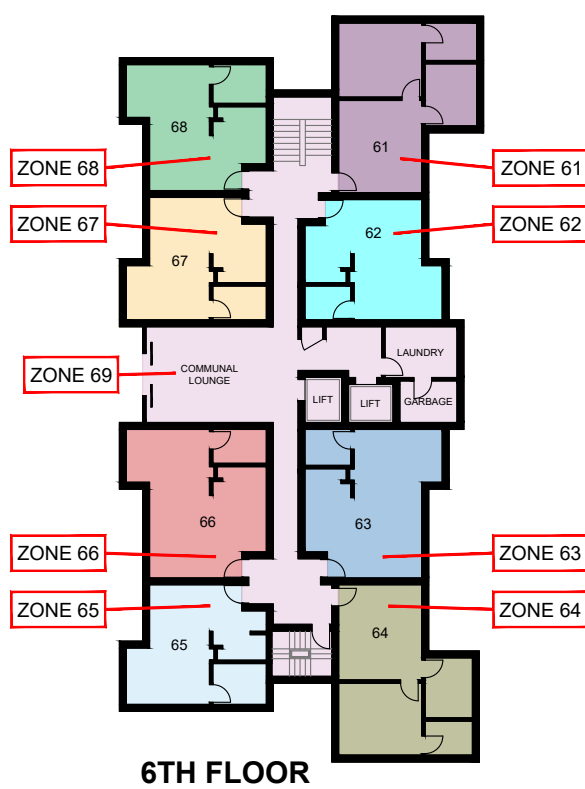

LEGEND

- FDCIE** FIRE INDICATOR PANEL
- ELECTRICAL SWITCHBOARD